




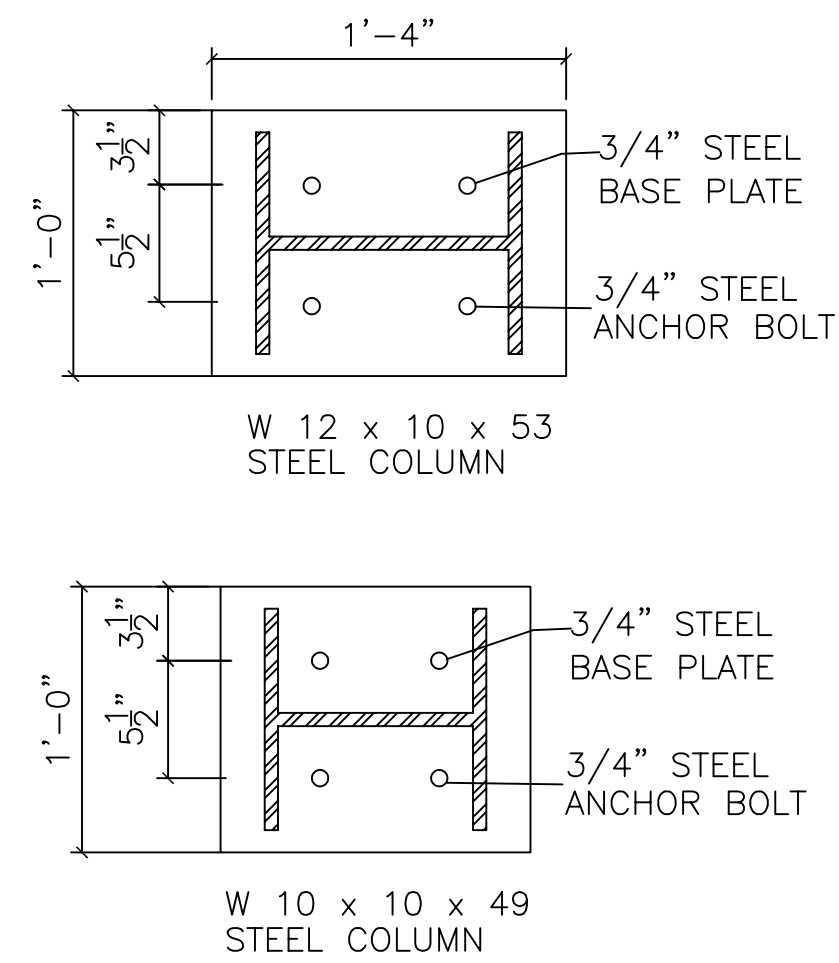


COLUMN BASE PLATE DETAILS
SCALE: NTS

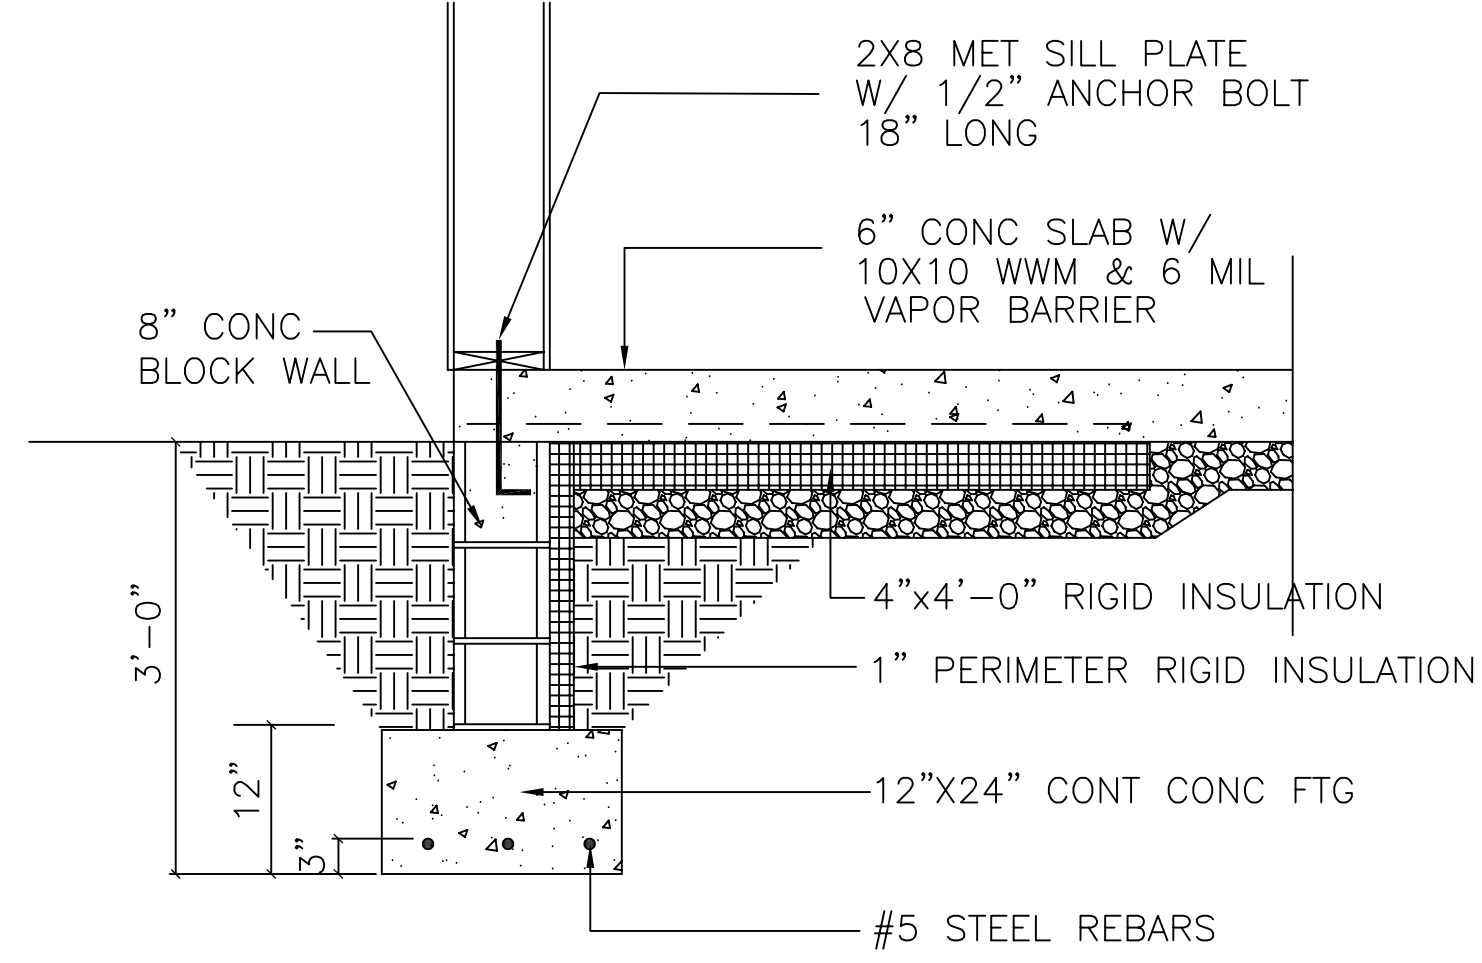


FOUNDATION WALL DETAIL
SCALE: 3/4"=1'-0"

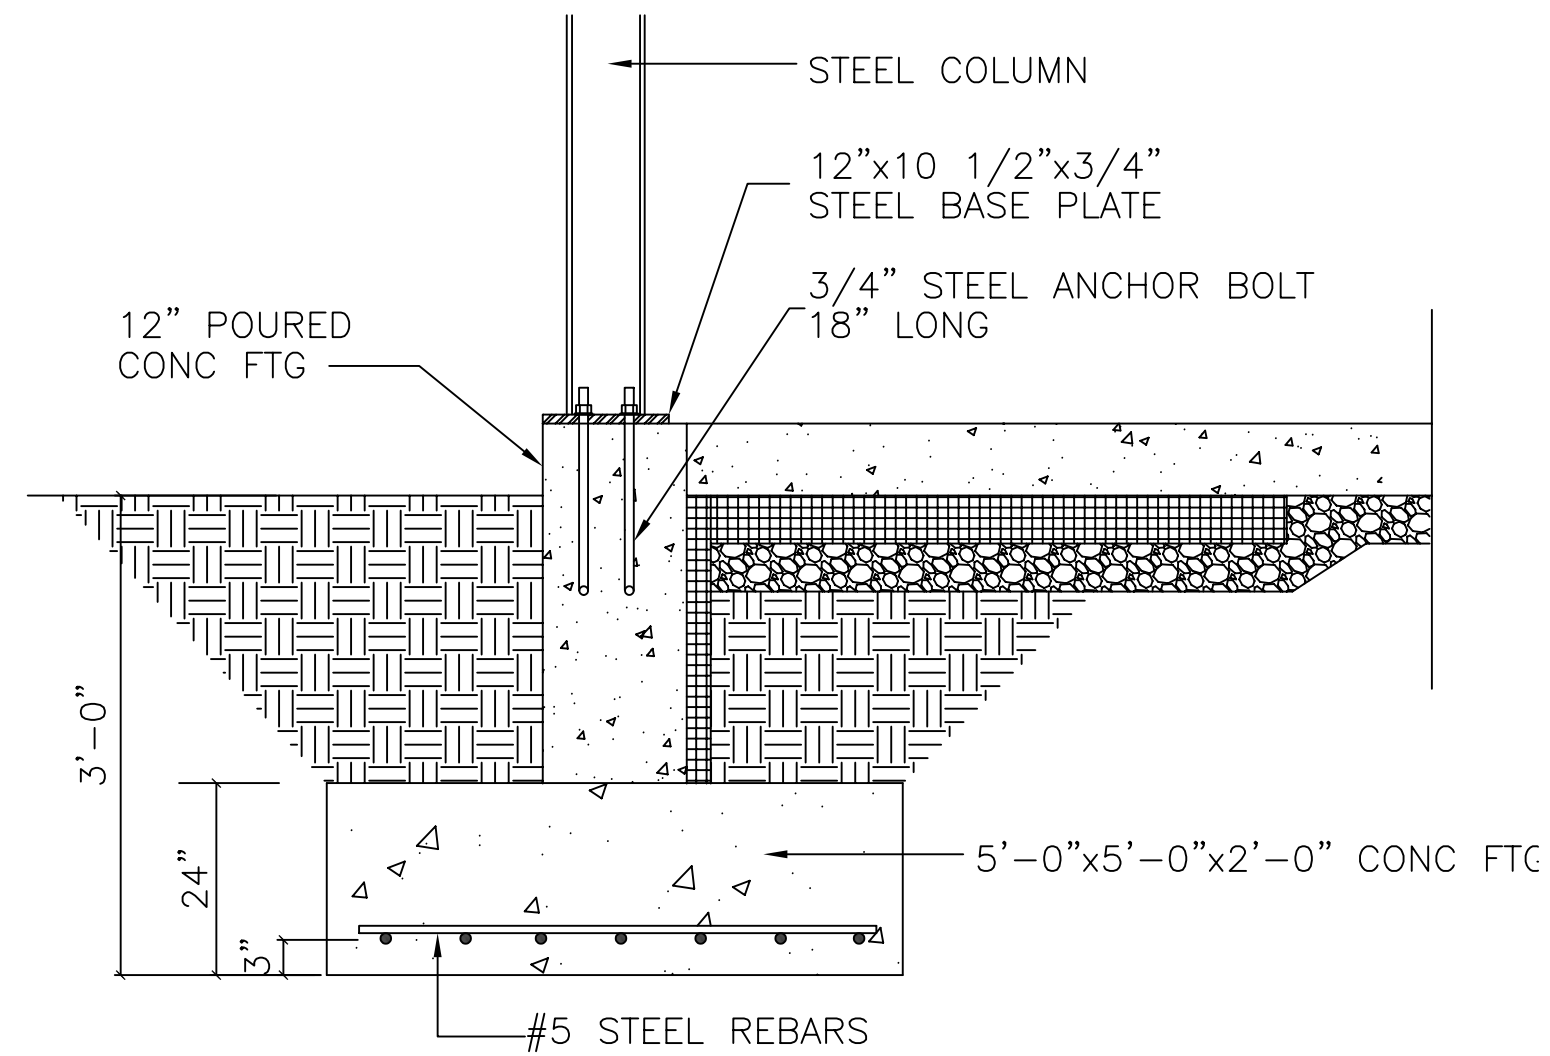


FOUNDATION WALL DETAIL @ COLUMN
SCALE: 3/4"=1'-0"

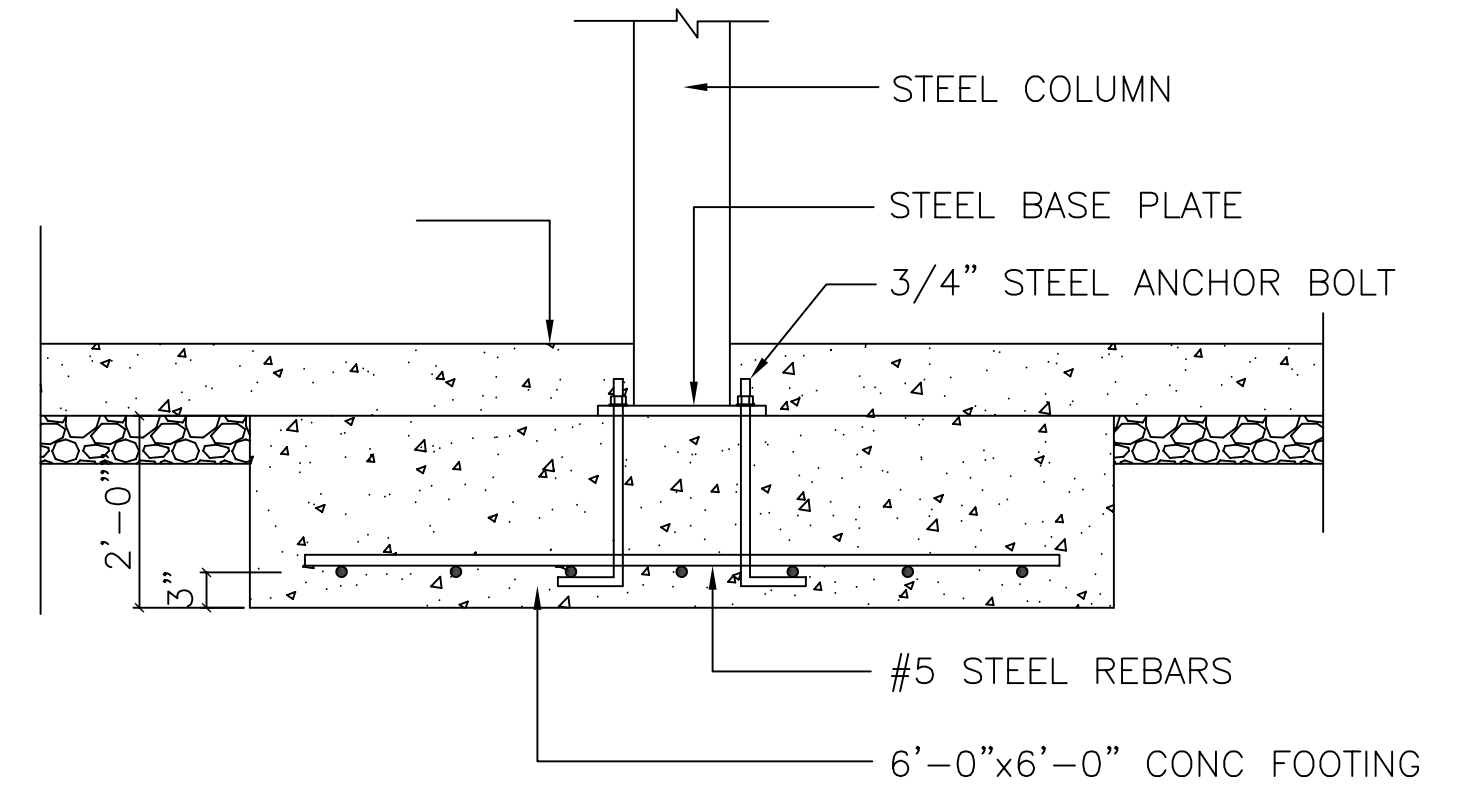


FOOTING DETAIL @ COLUMN
SCALE: 3/4"=1'-0"

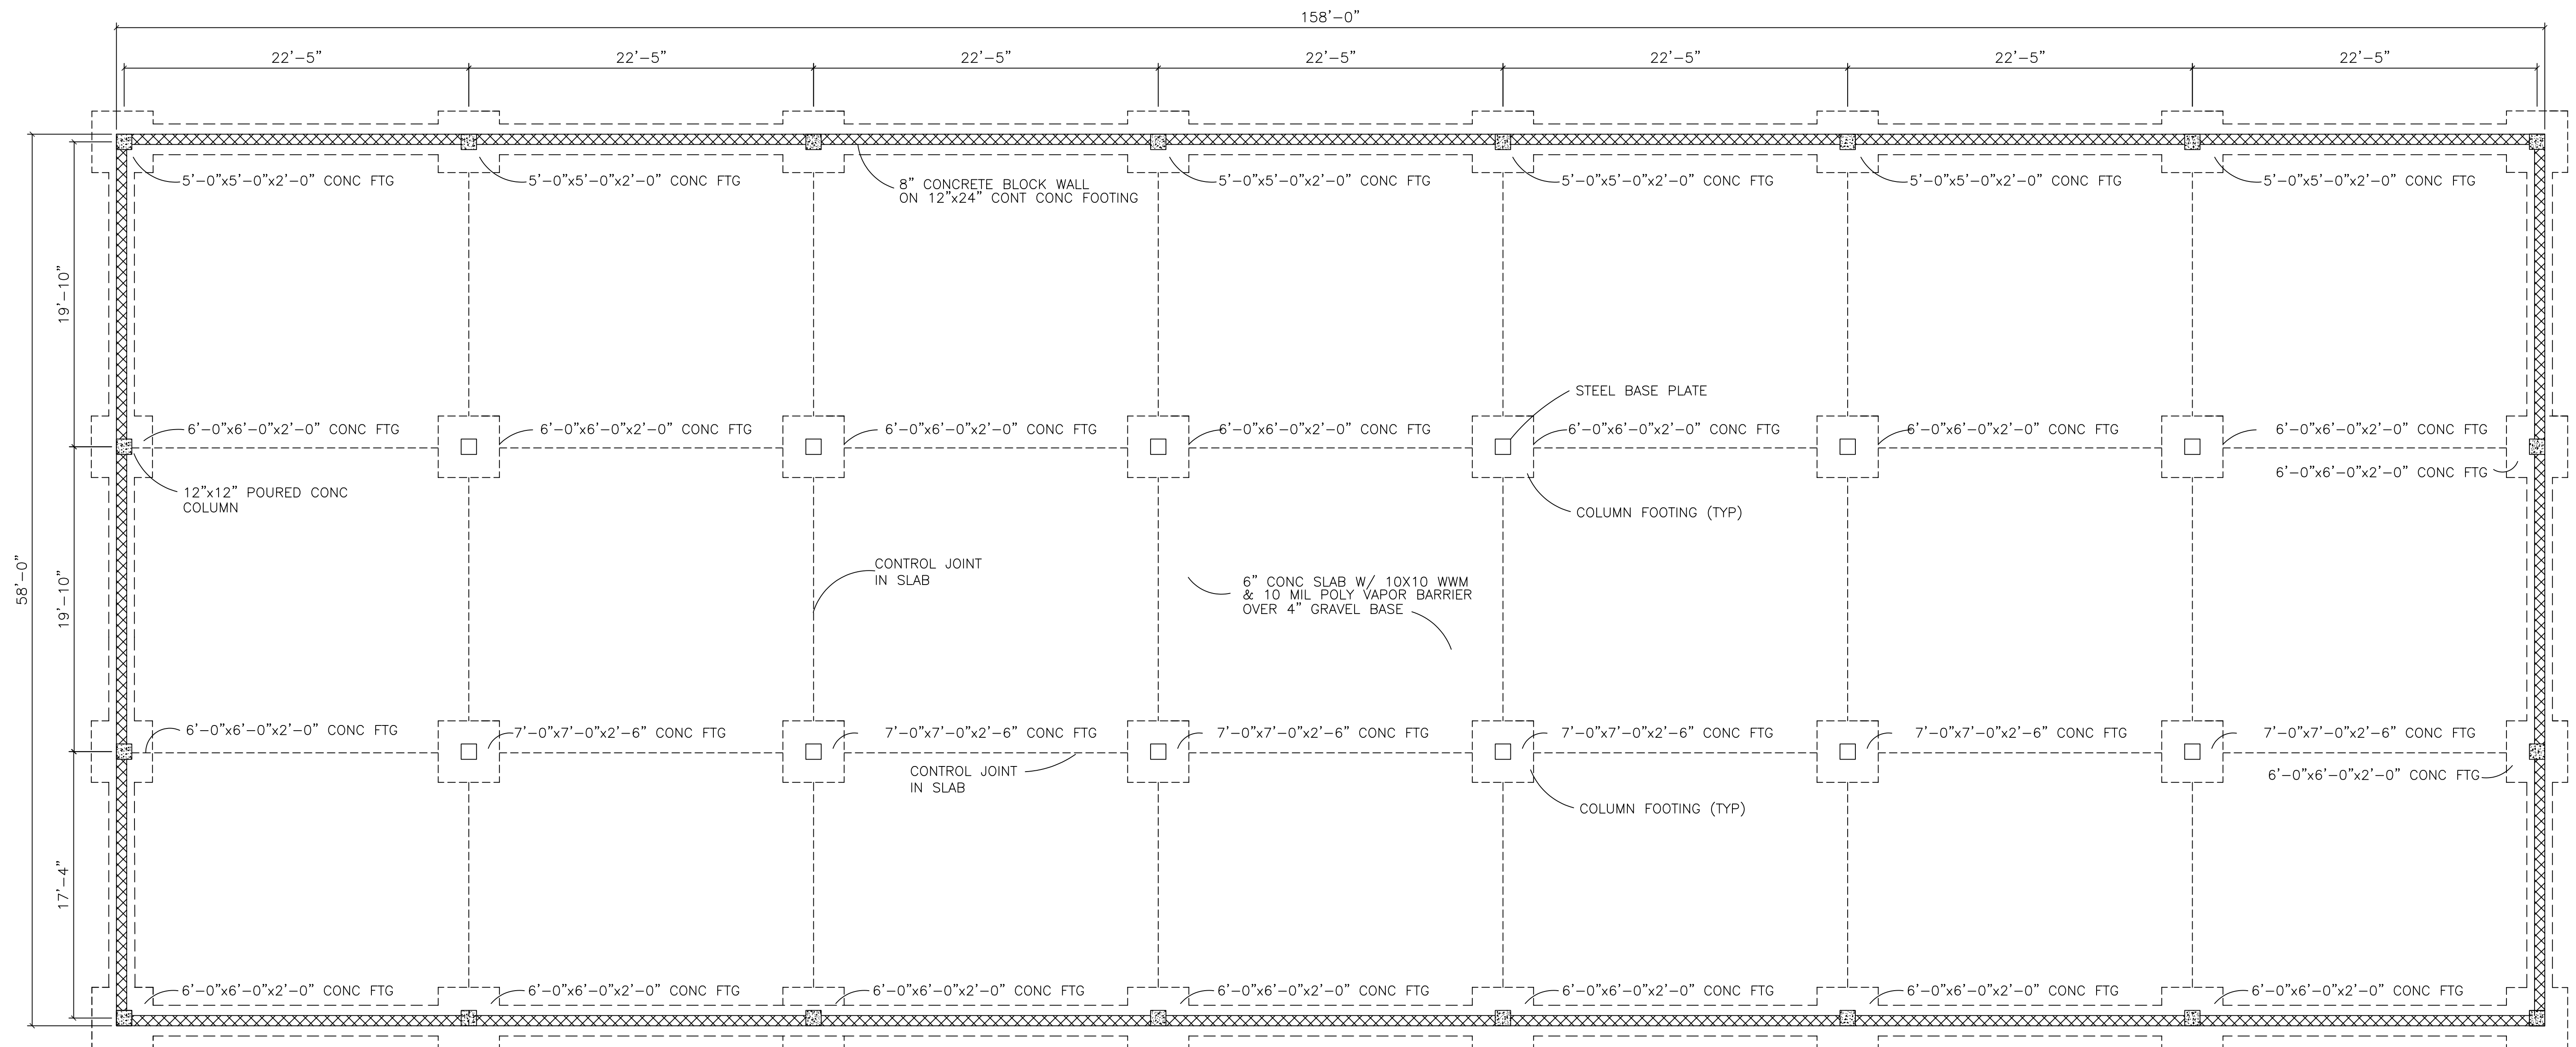


FOUNDATION PLAN
SCALE: 3/16"=1'-0"

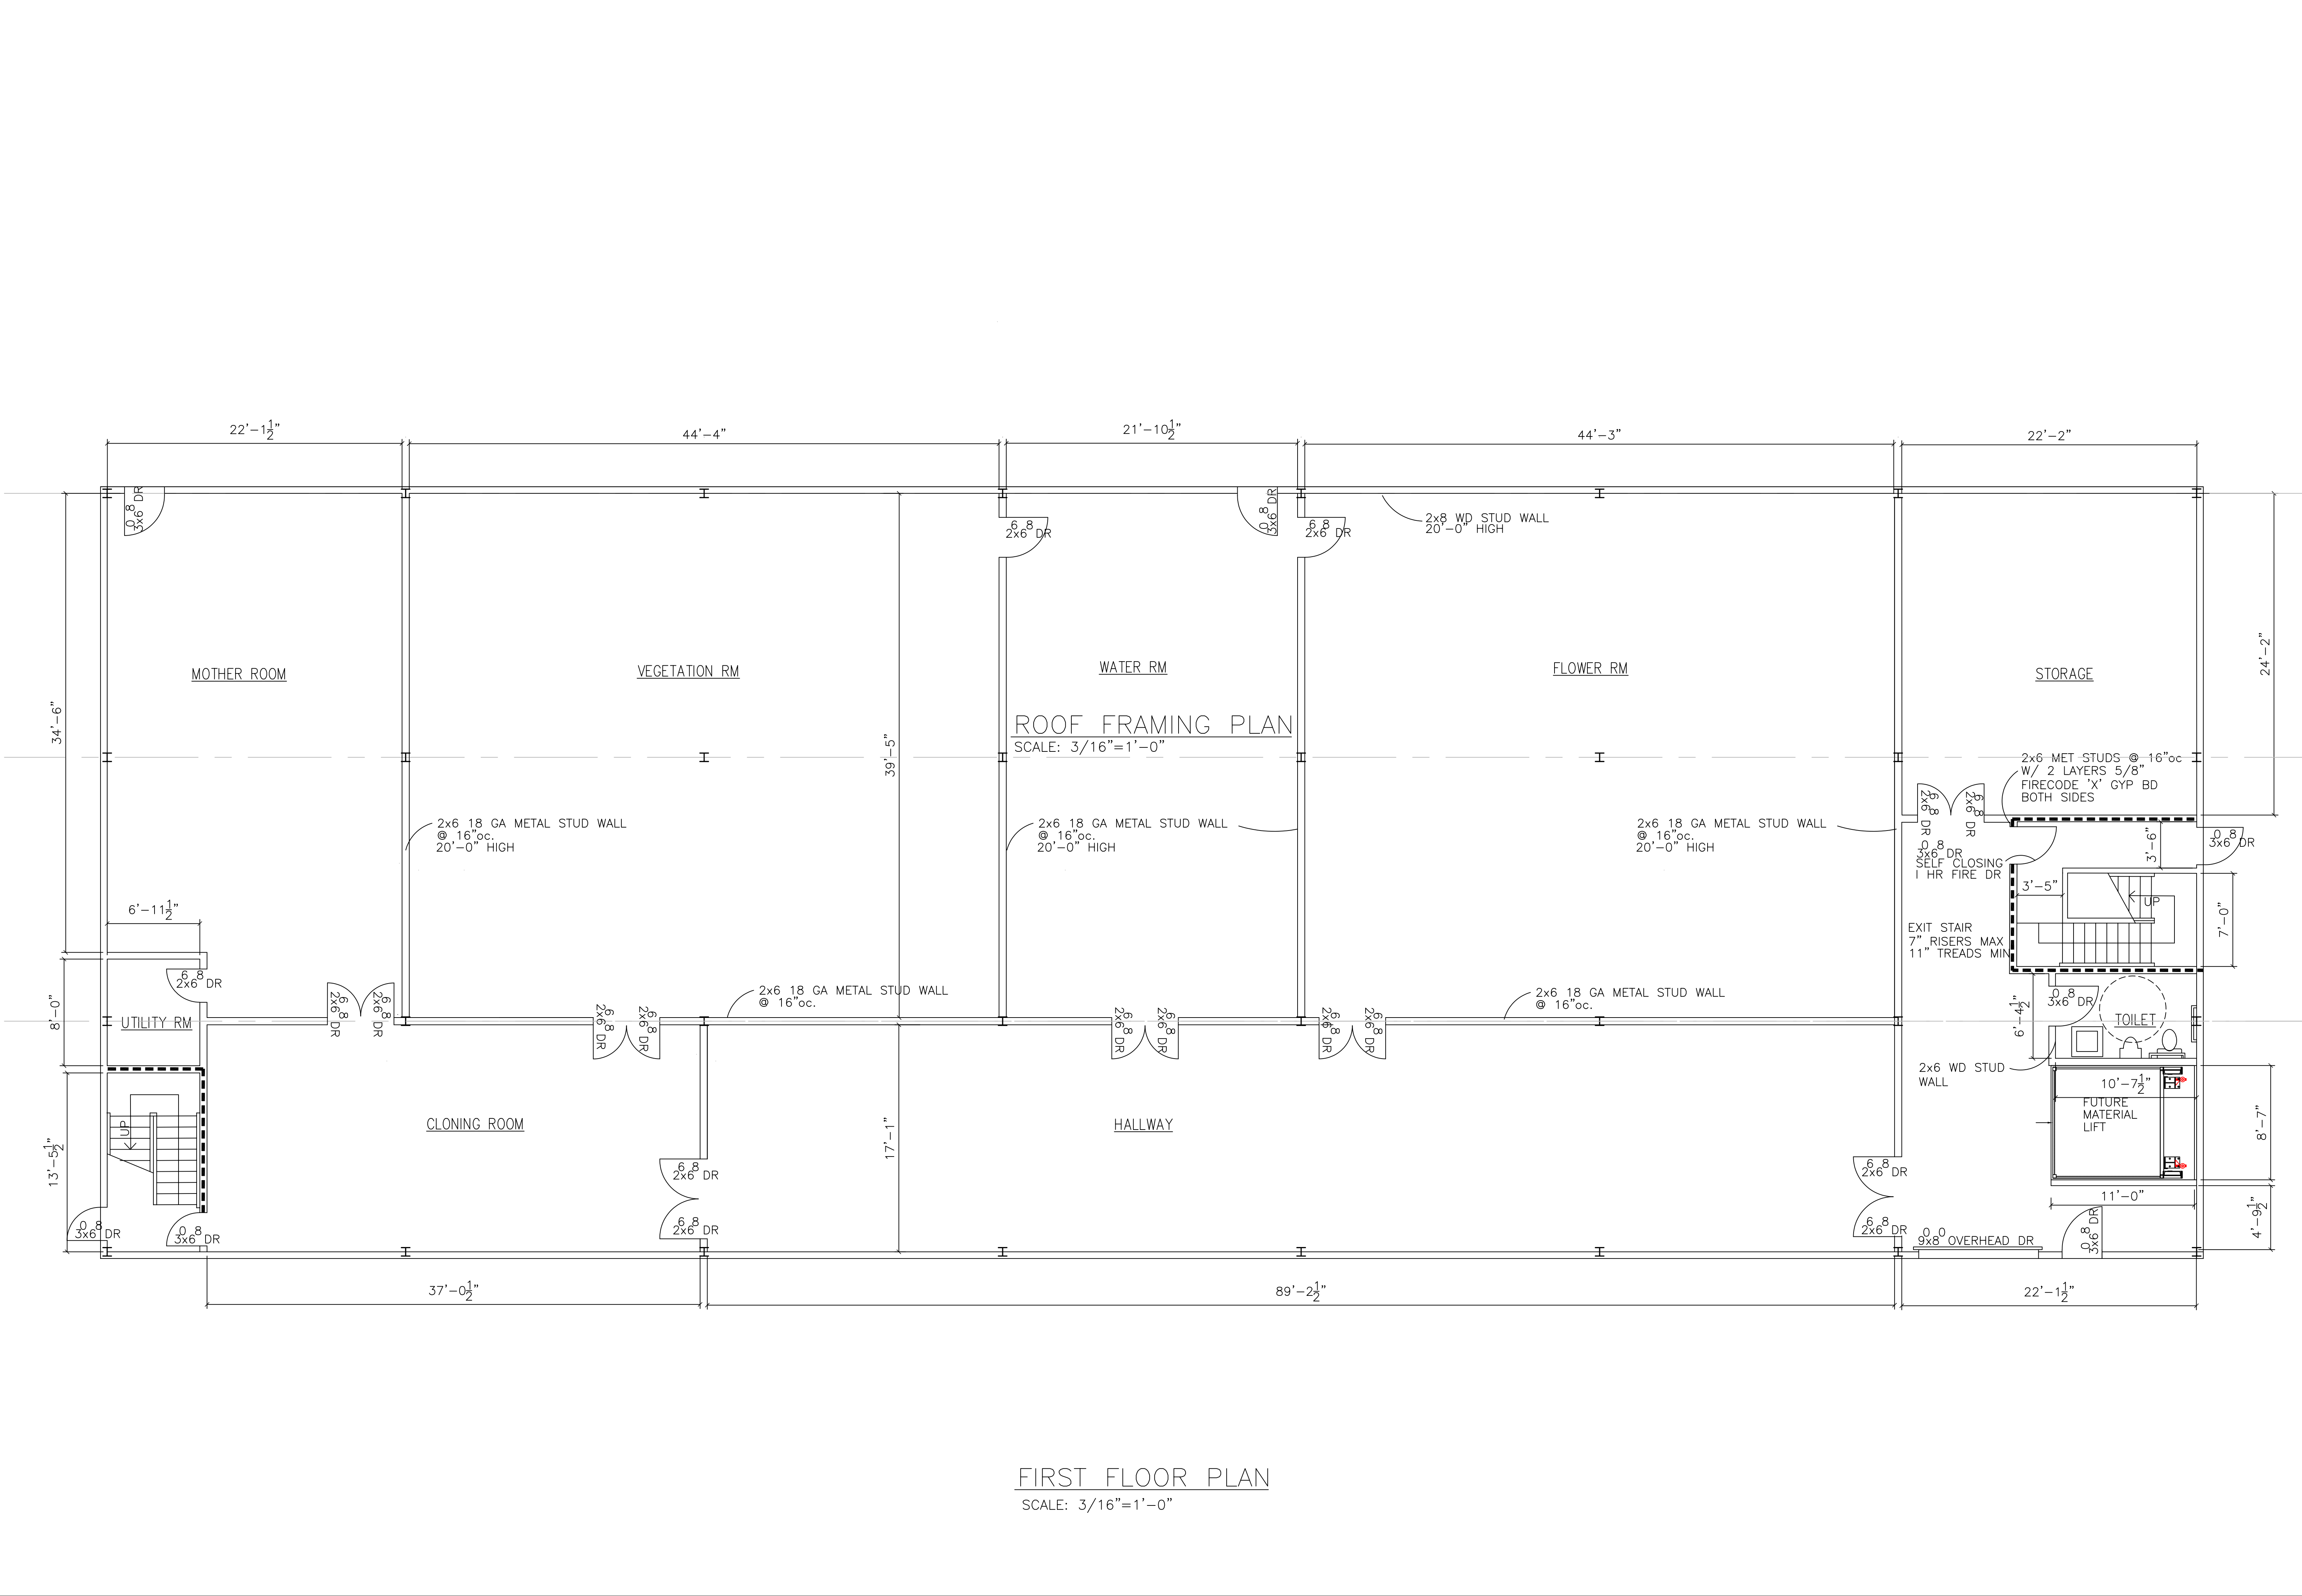

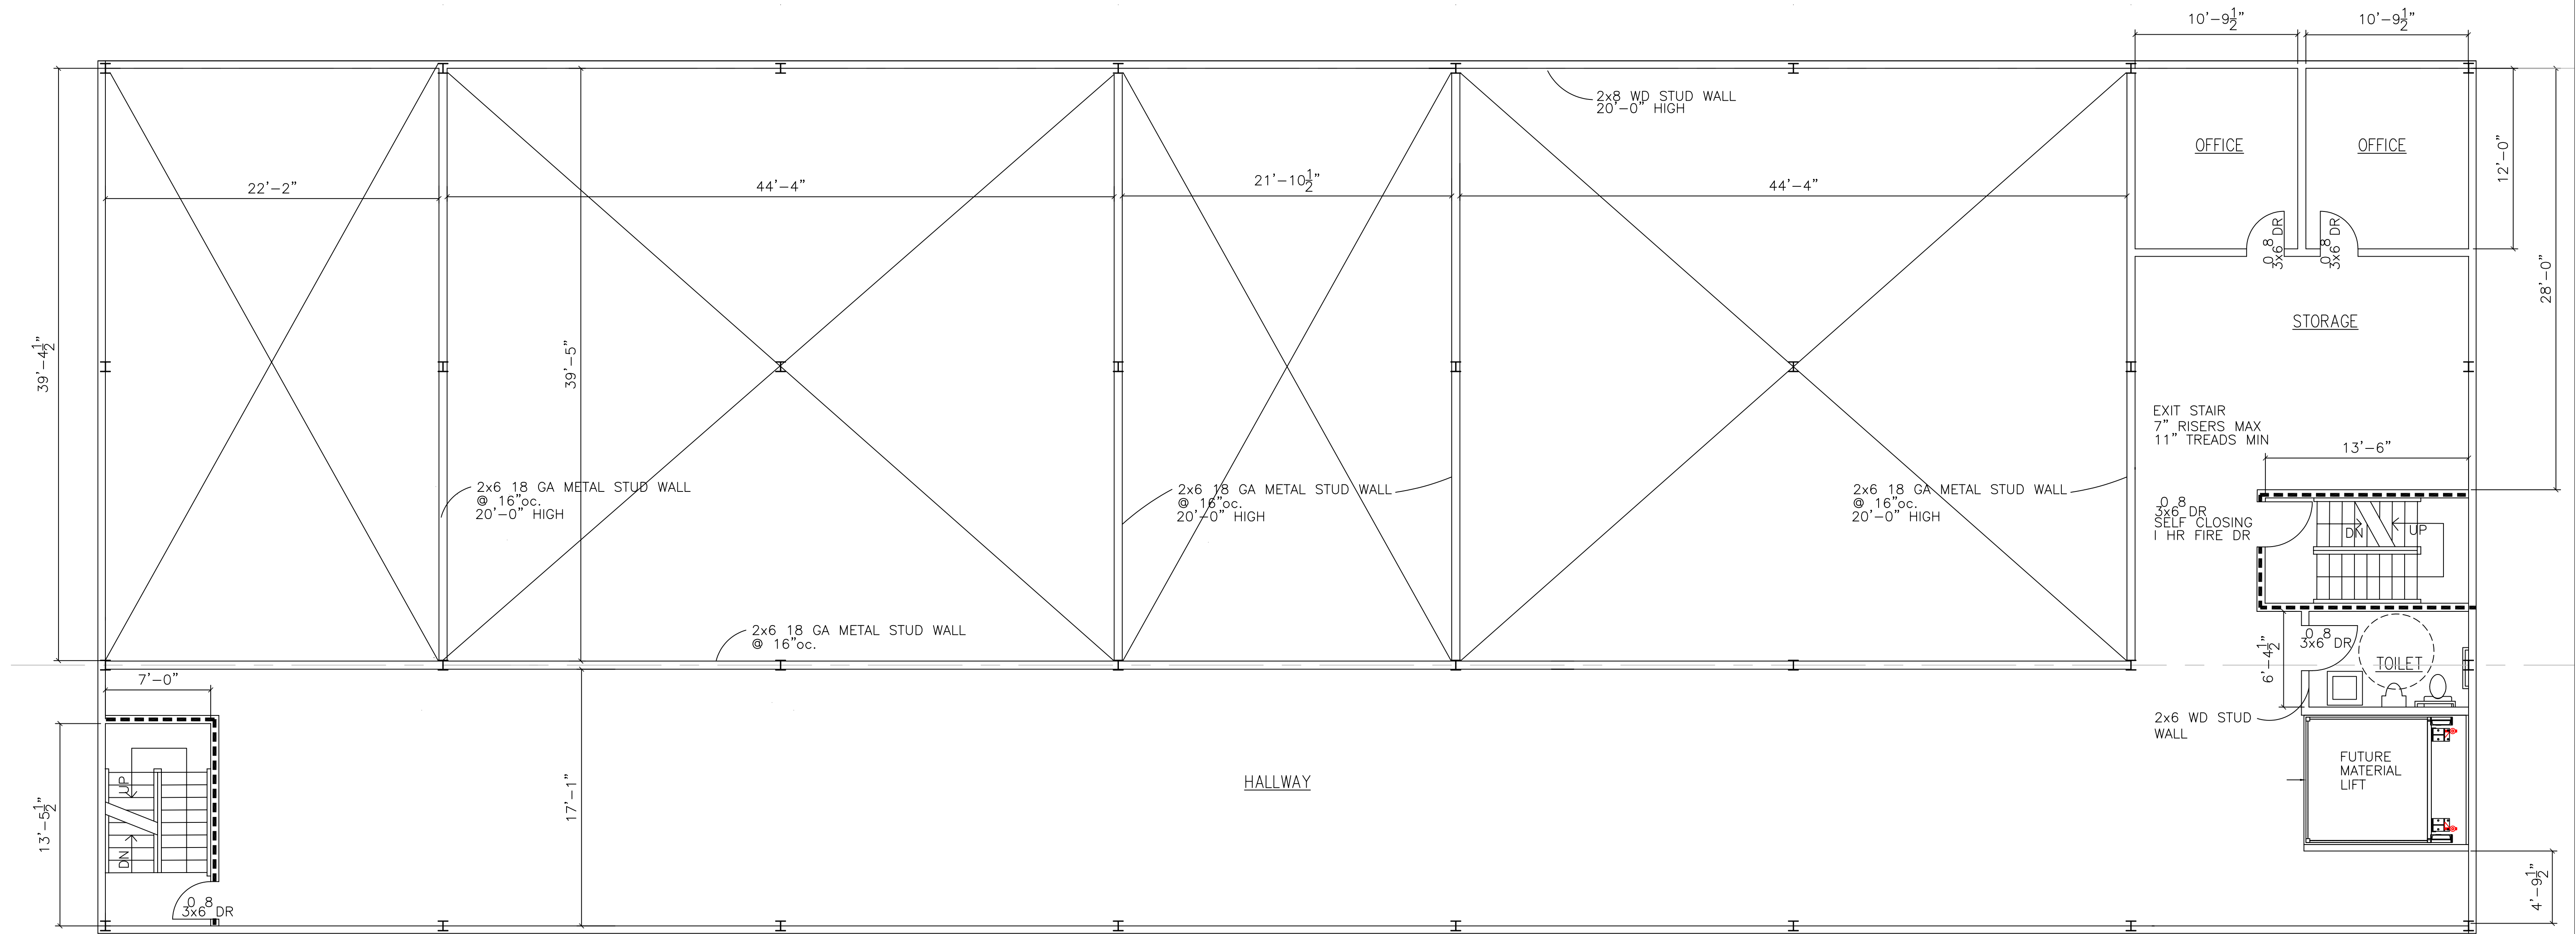


MEZZANINE PLAN

SCALE: 3/16"=1'-0"

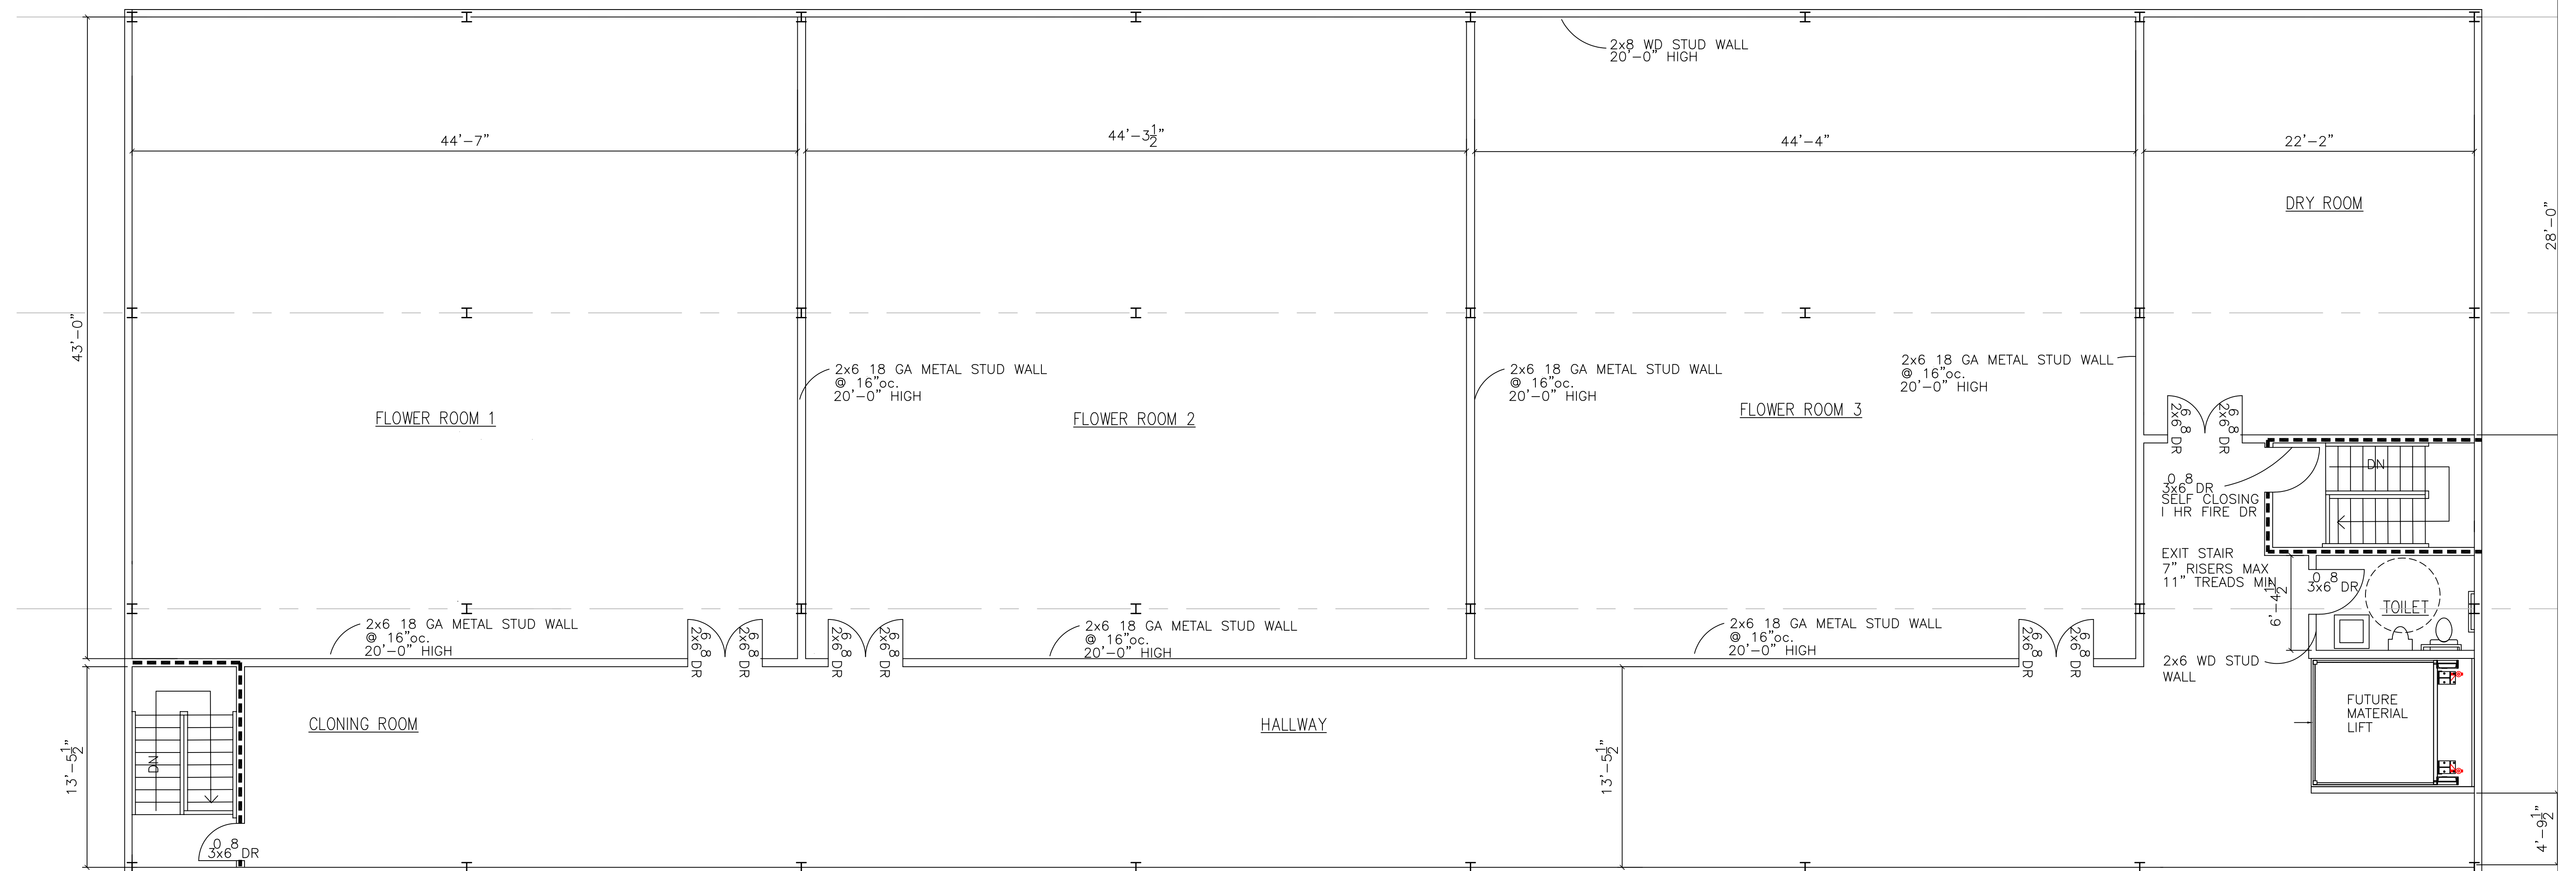

SCALE: $3/16"=1'-0"$

 

ROOF PLAN
SCALE: 3/16"=1'-0"

Deck V3 (ALL Page)										
	Description	Deck Type	Deck Gauge	Deck Finish	Lap or Waste	Deck SQ	No of Floors	Screw Pattern	Screw Total	Comments-Add'l Loads
	Composite Floor	BL36	20	G60	No Lap/Waste	124.80	1 Floor	36" O/C	1,390	
	Roof	B36	20	G60	2%	94.07	1 Floor	24" O/C	1,568	


Deck Accessories (ALL Page)				
	Label	Description	Total Length	Total Qty's
	1.5" Cell Closure	Cell Closure	228.59	280.00
				Linear Feet

Qualifications:

Roof deck quoted with 1.5B, 20Ga, G60 finish (gauge not indicated on drawings).
Floor deck quoted with 1.5BL, 20Ga, G60 finish (gauge not indicated on drawings).
15 PSF net uplift has been considered.
Considered joists where joist span is greater than 6'-0"


Exclusions:

Pourstop.
Design for axial load, Slope on joist.
TCX @ Peripheral Joists.

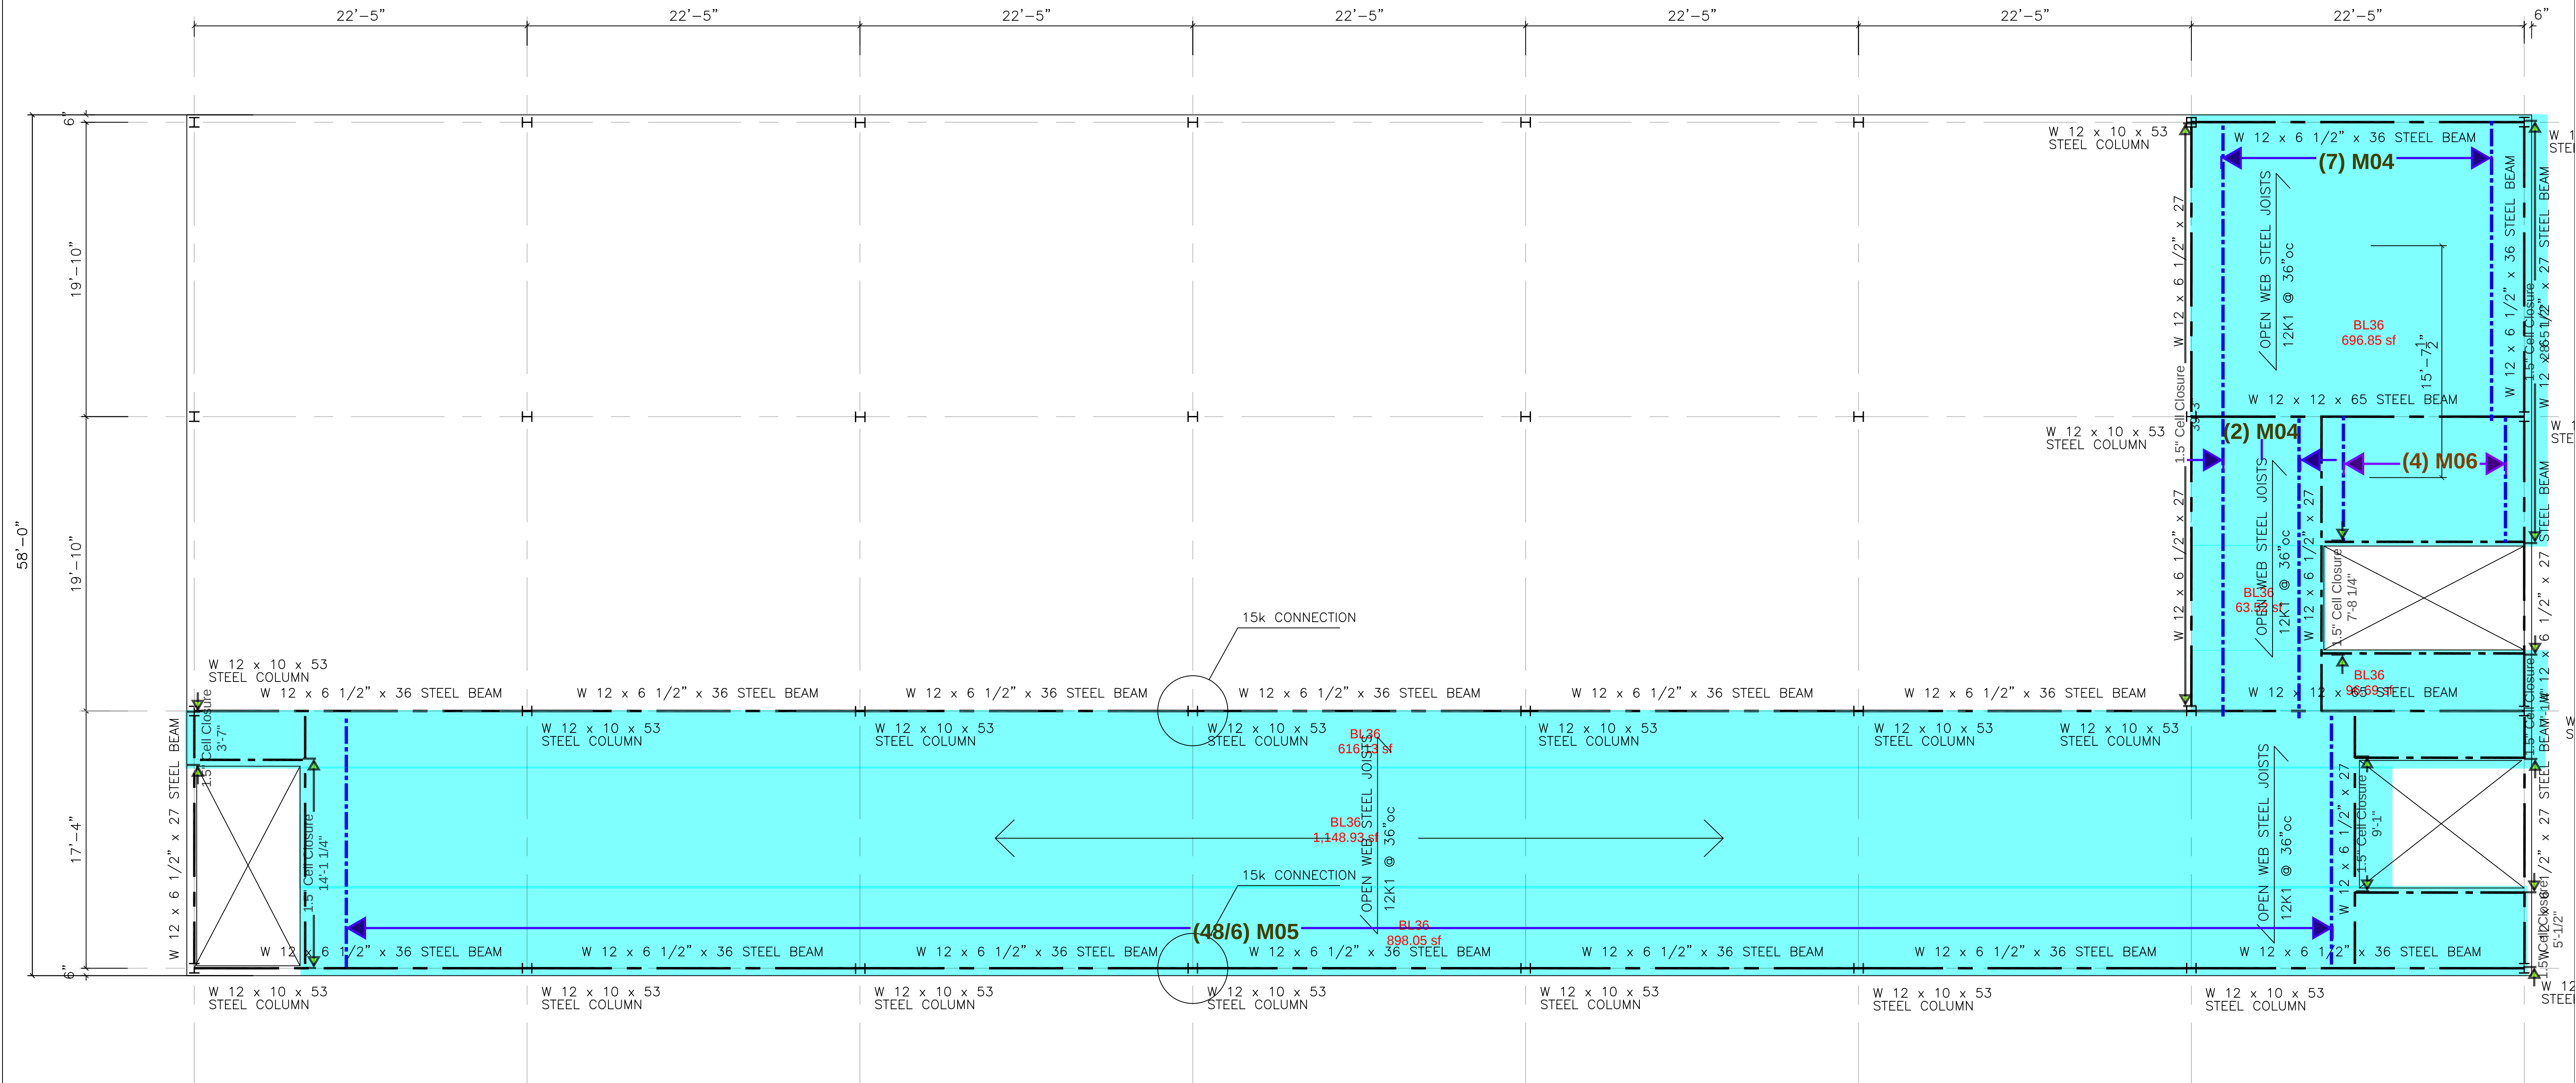


MEZZANINE STRUCTURAL PLAN
SCALE: 3/16"=1'-0"


J=61/6

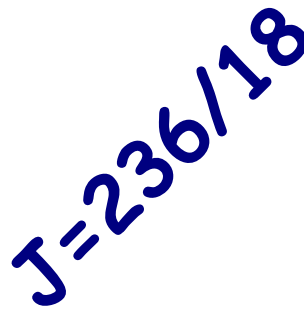

 
SECOND FLOOR STRUCTURAL PLAN
SCALE: 3/16"=1'-0"



REAR ELEVATION
SCALE: 1/8"=1'-0"

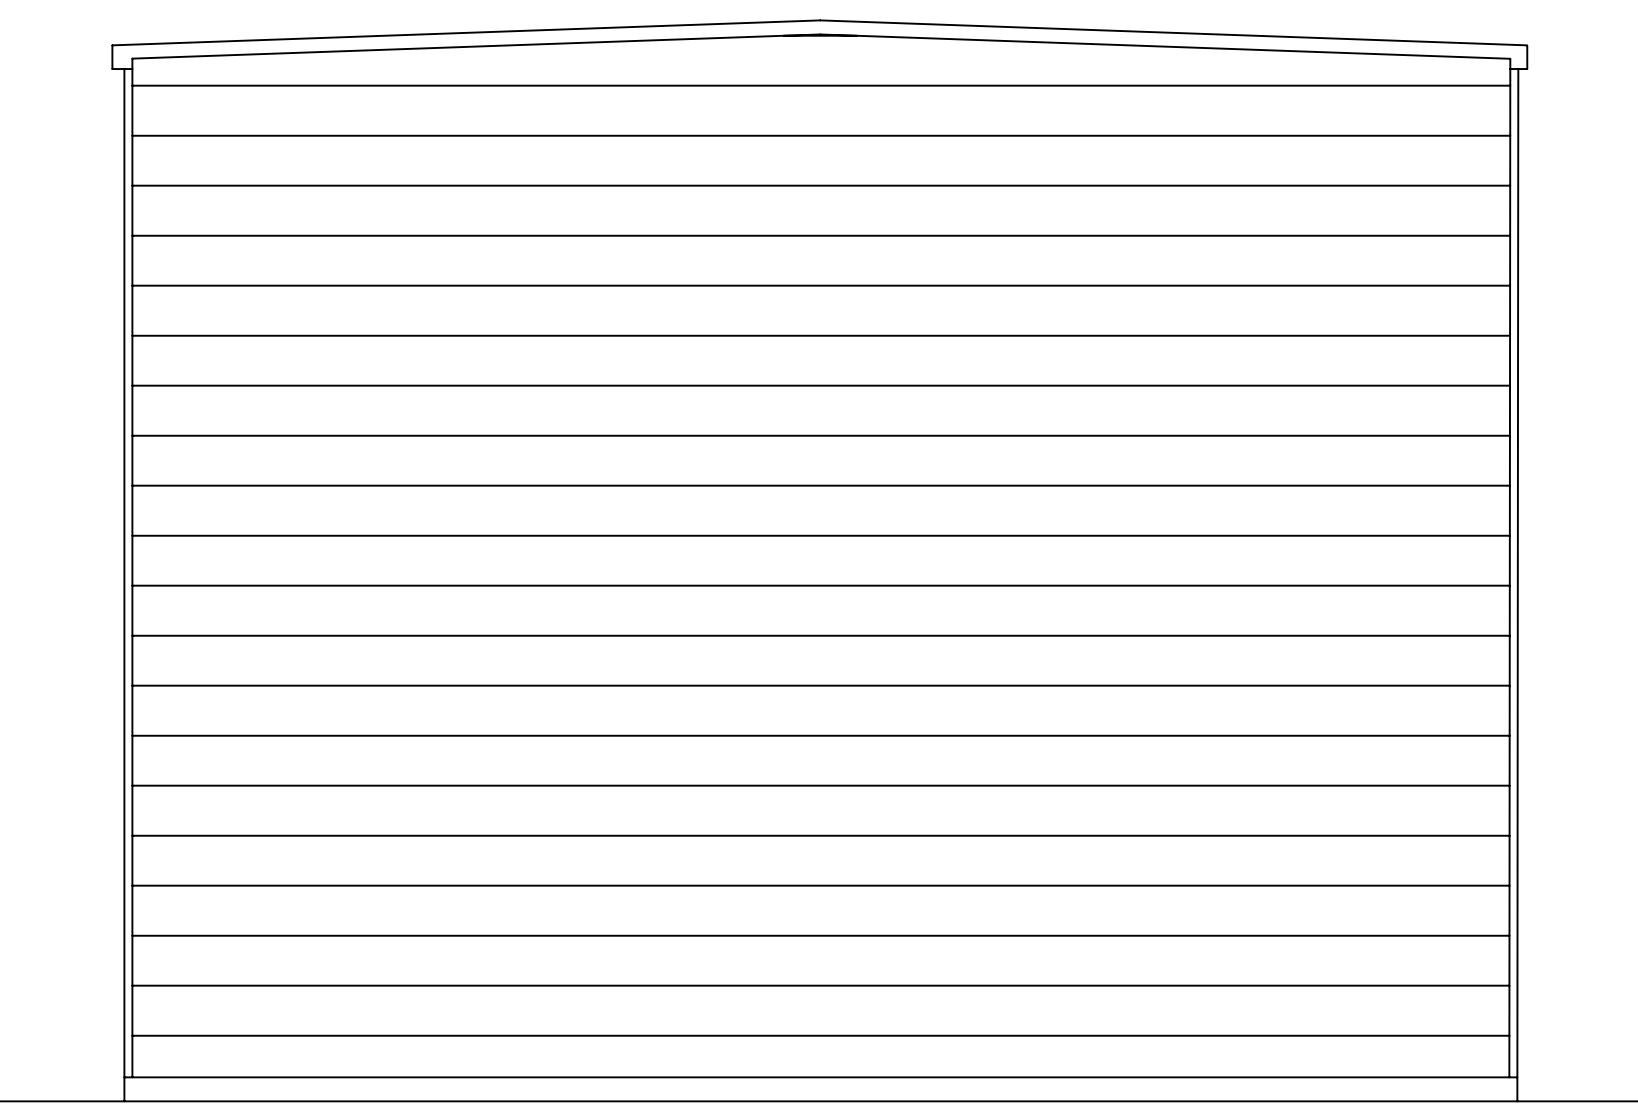


SIDE ELEVATION
SCALE: 1/8"=1'-0"

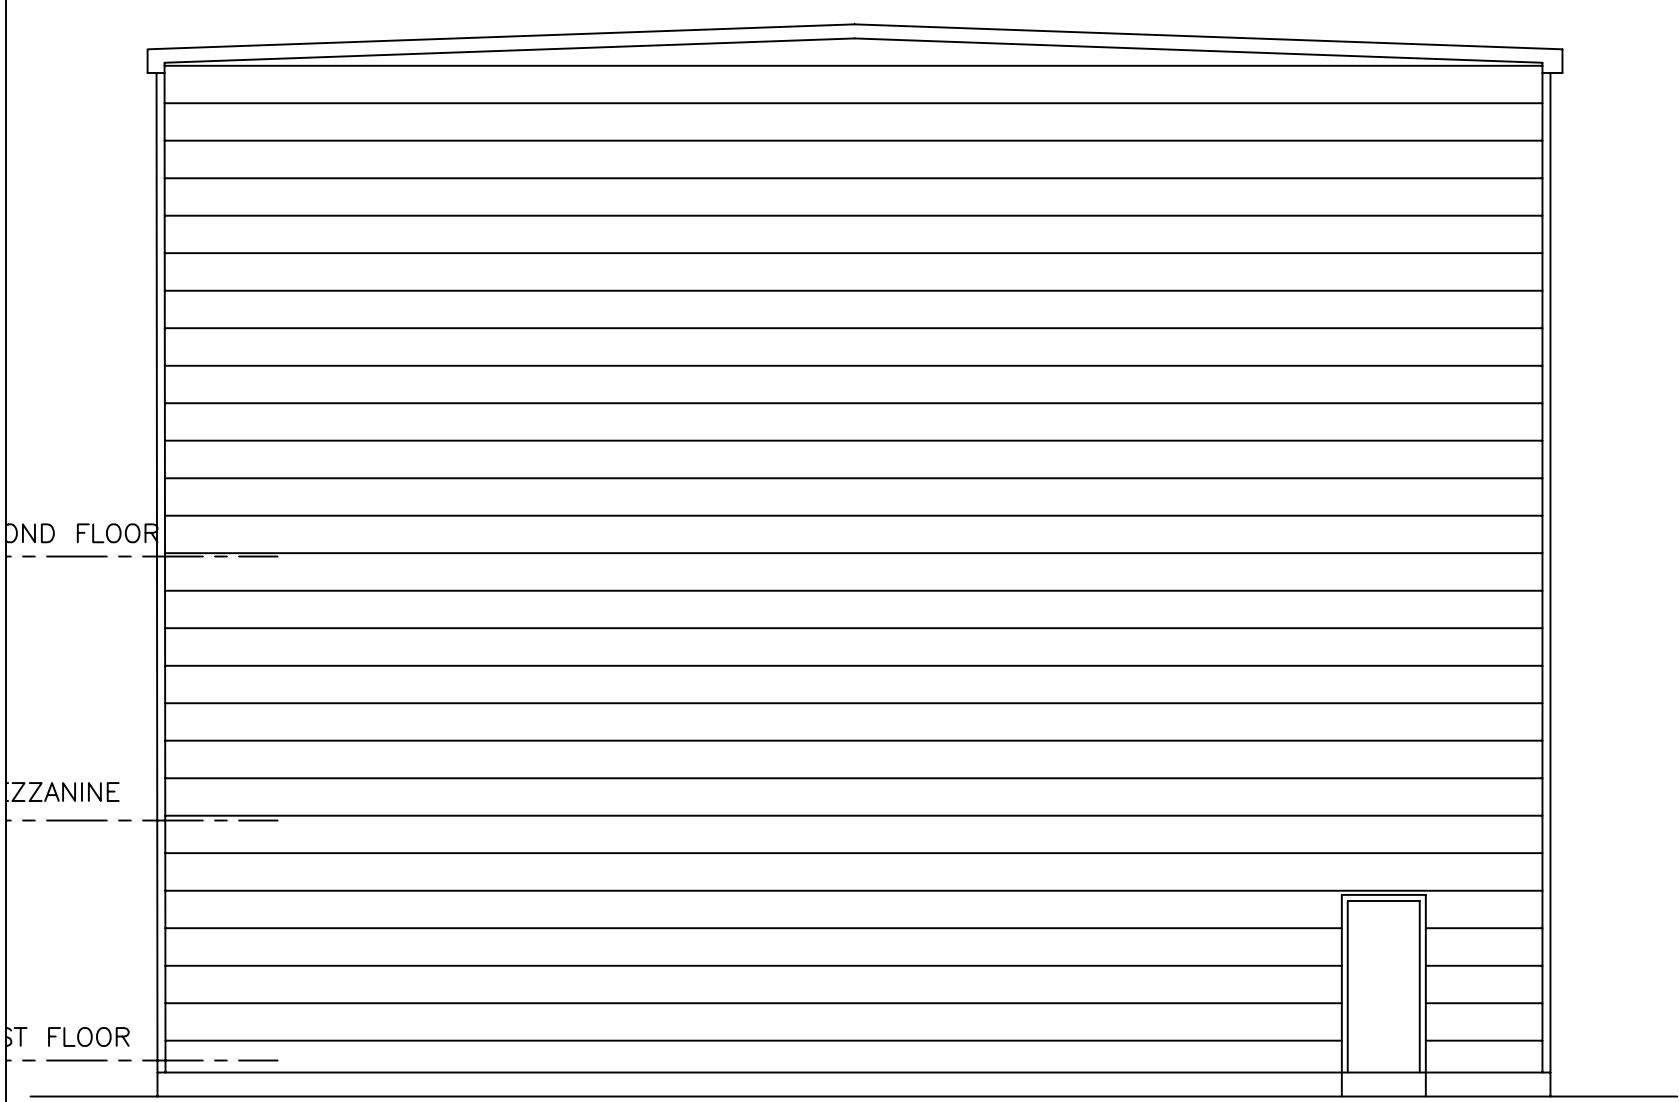

SIDE ELEVATION
SCALE: 1/8"=1'-0"




FRONT ELEVATION
SCALE: 1/8"=1'-0"

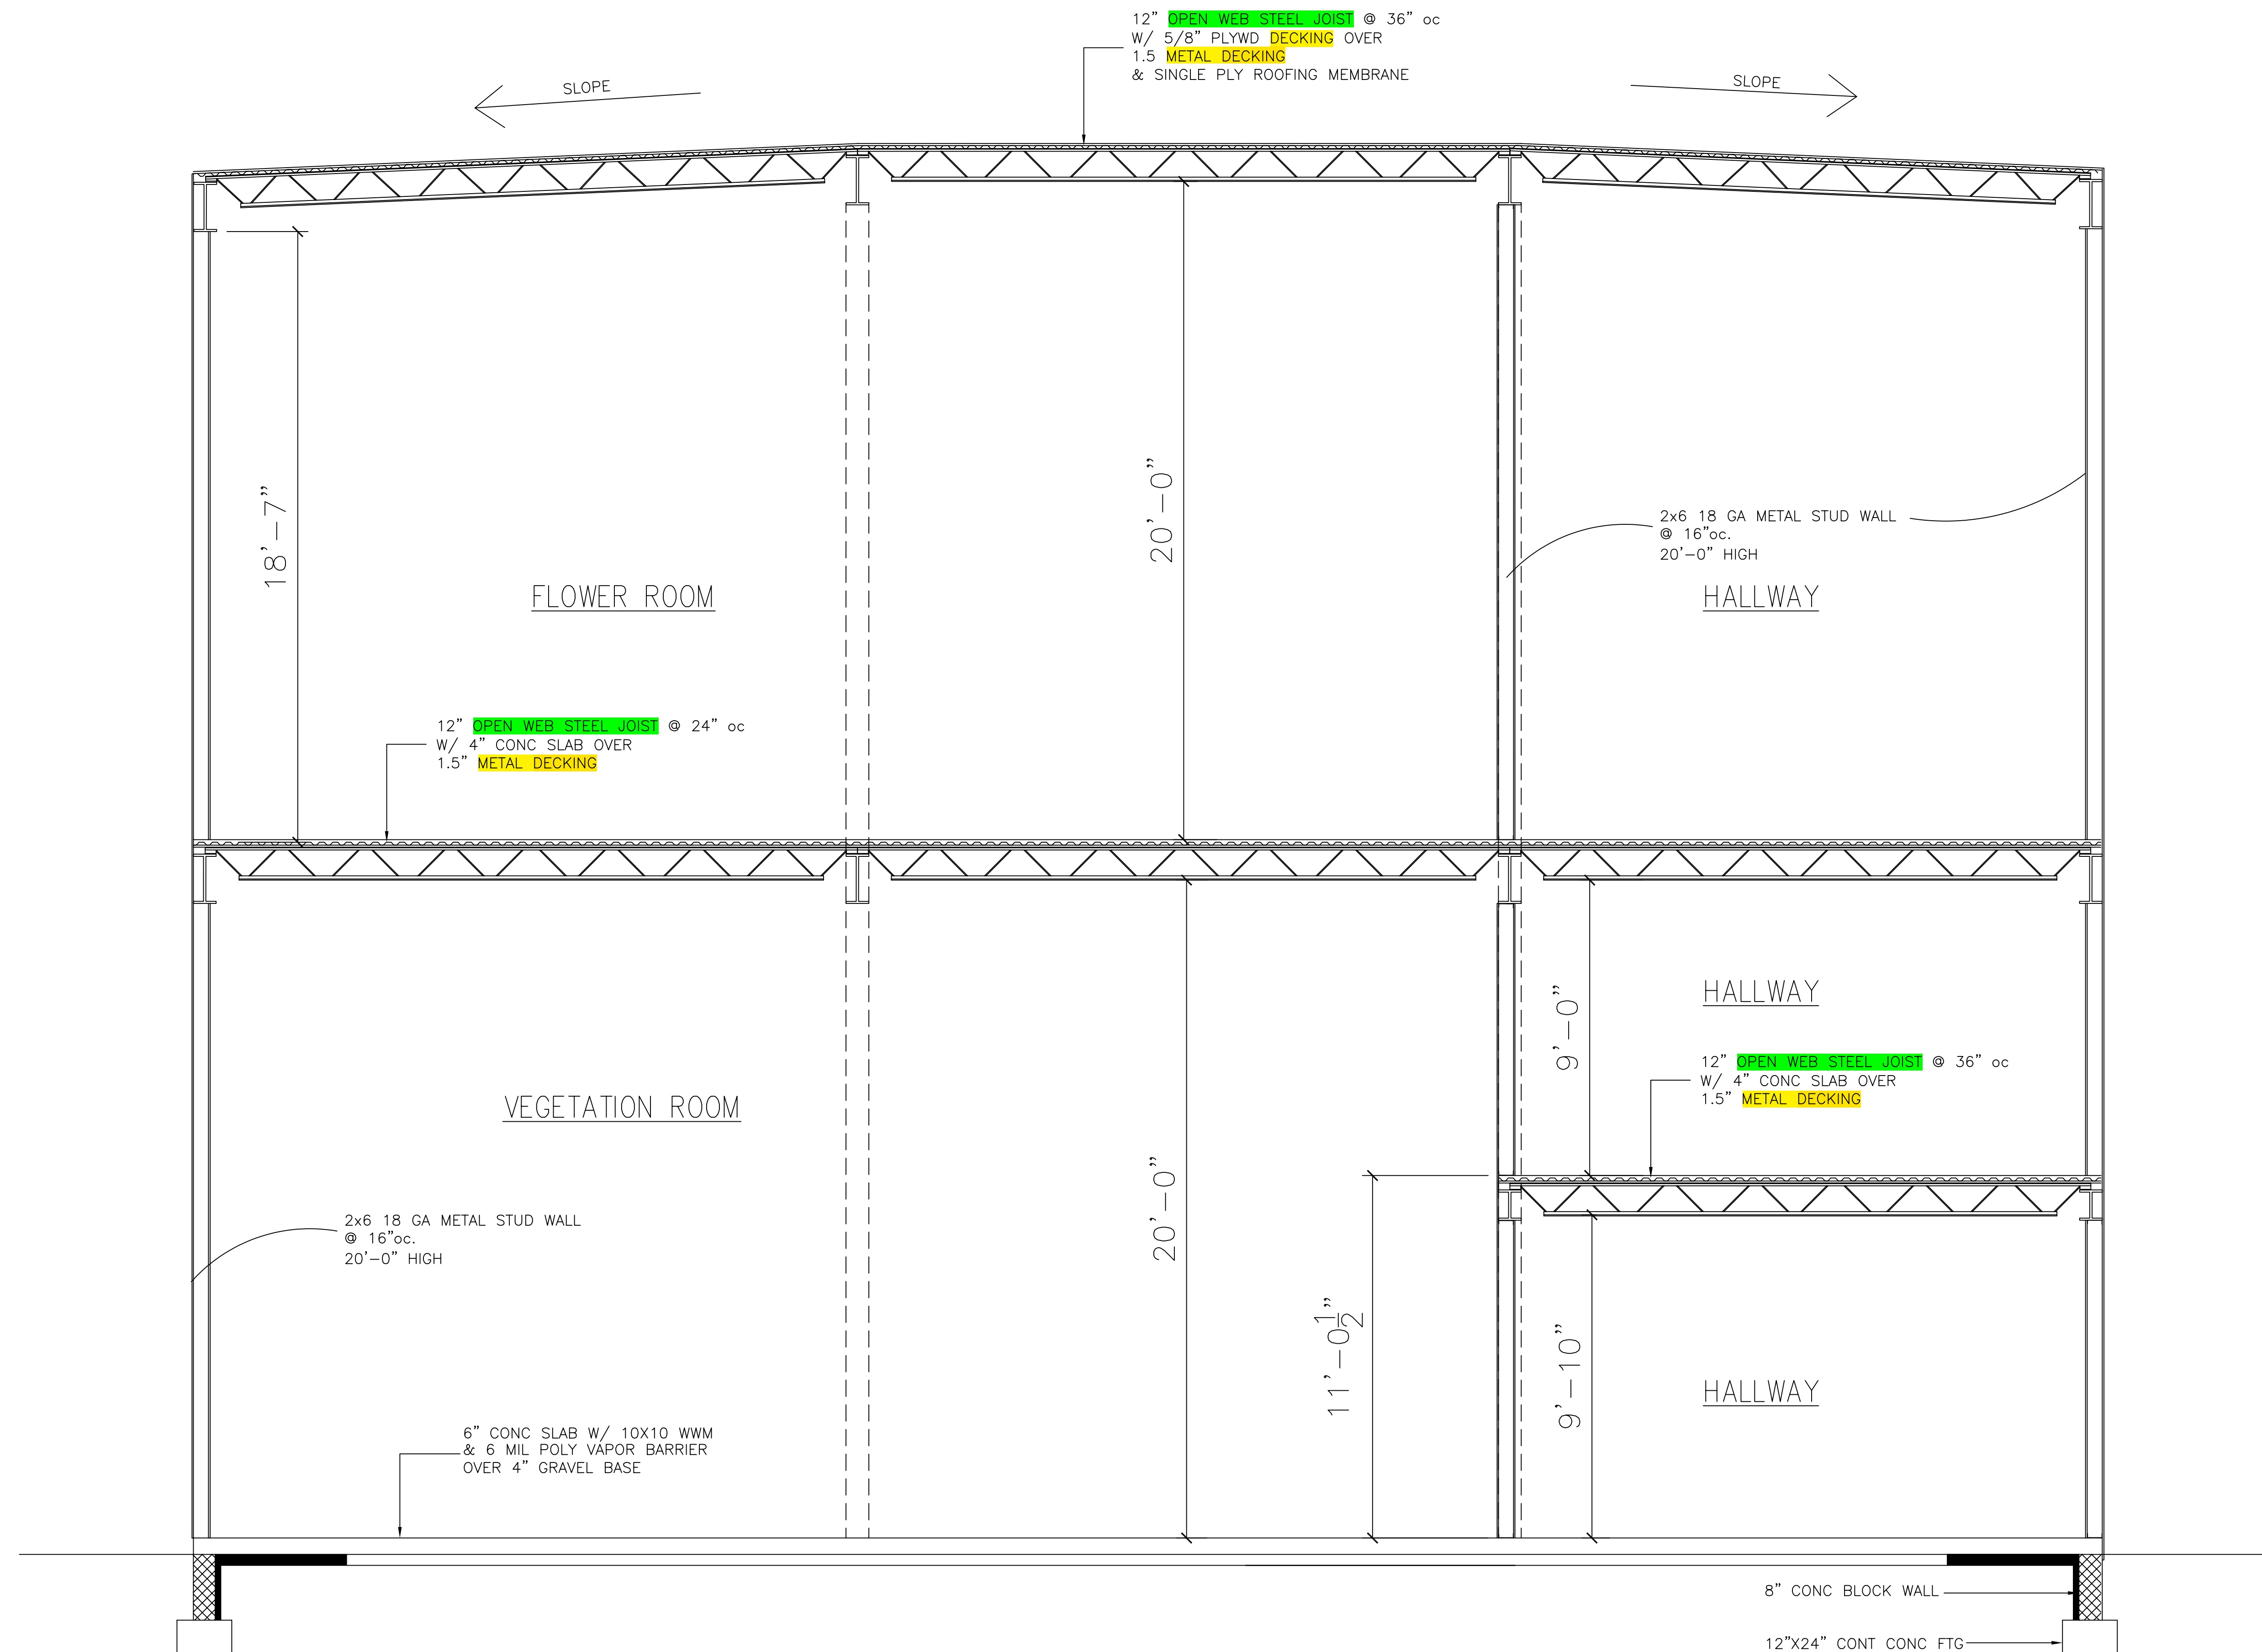


BUILDING SECTION
SCALE: 3/8"=1'-0"




BUILDING SECTION @ MEZZANINE
SCALE: 3/8"=1'-0"

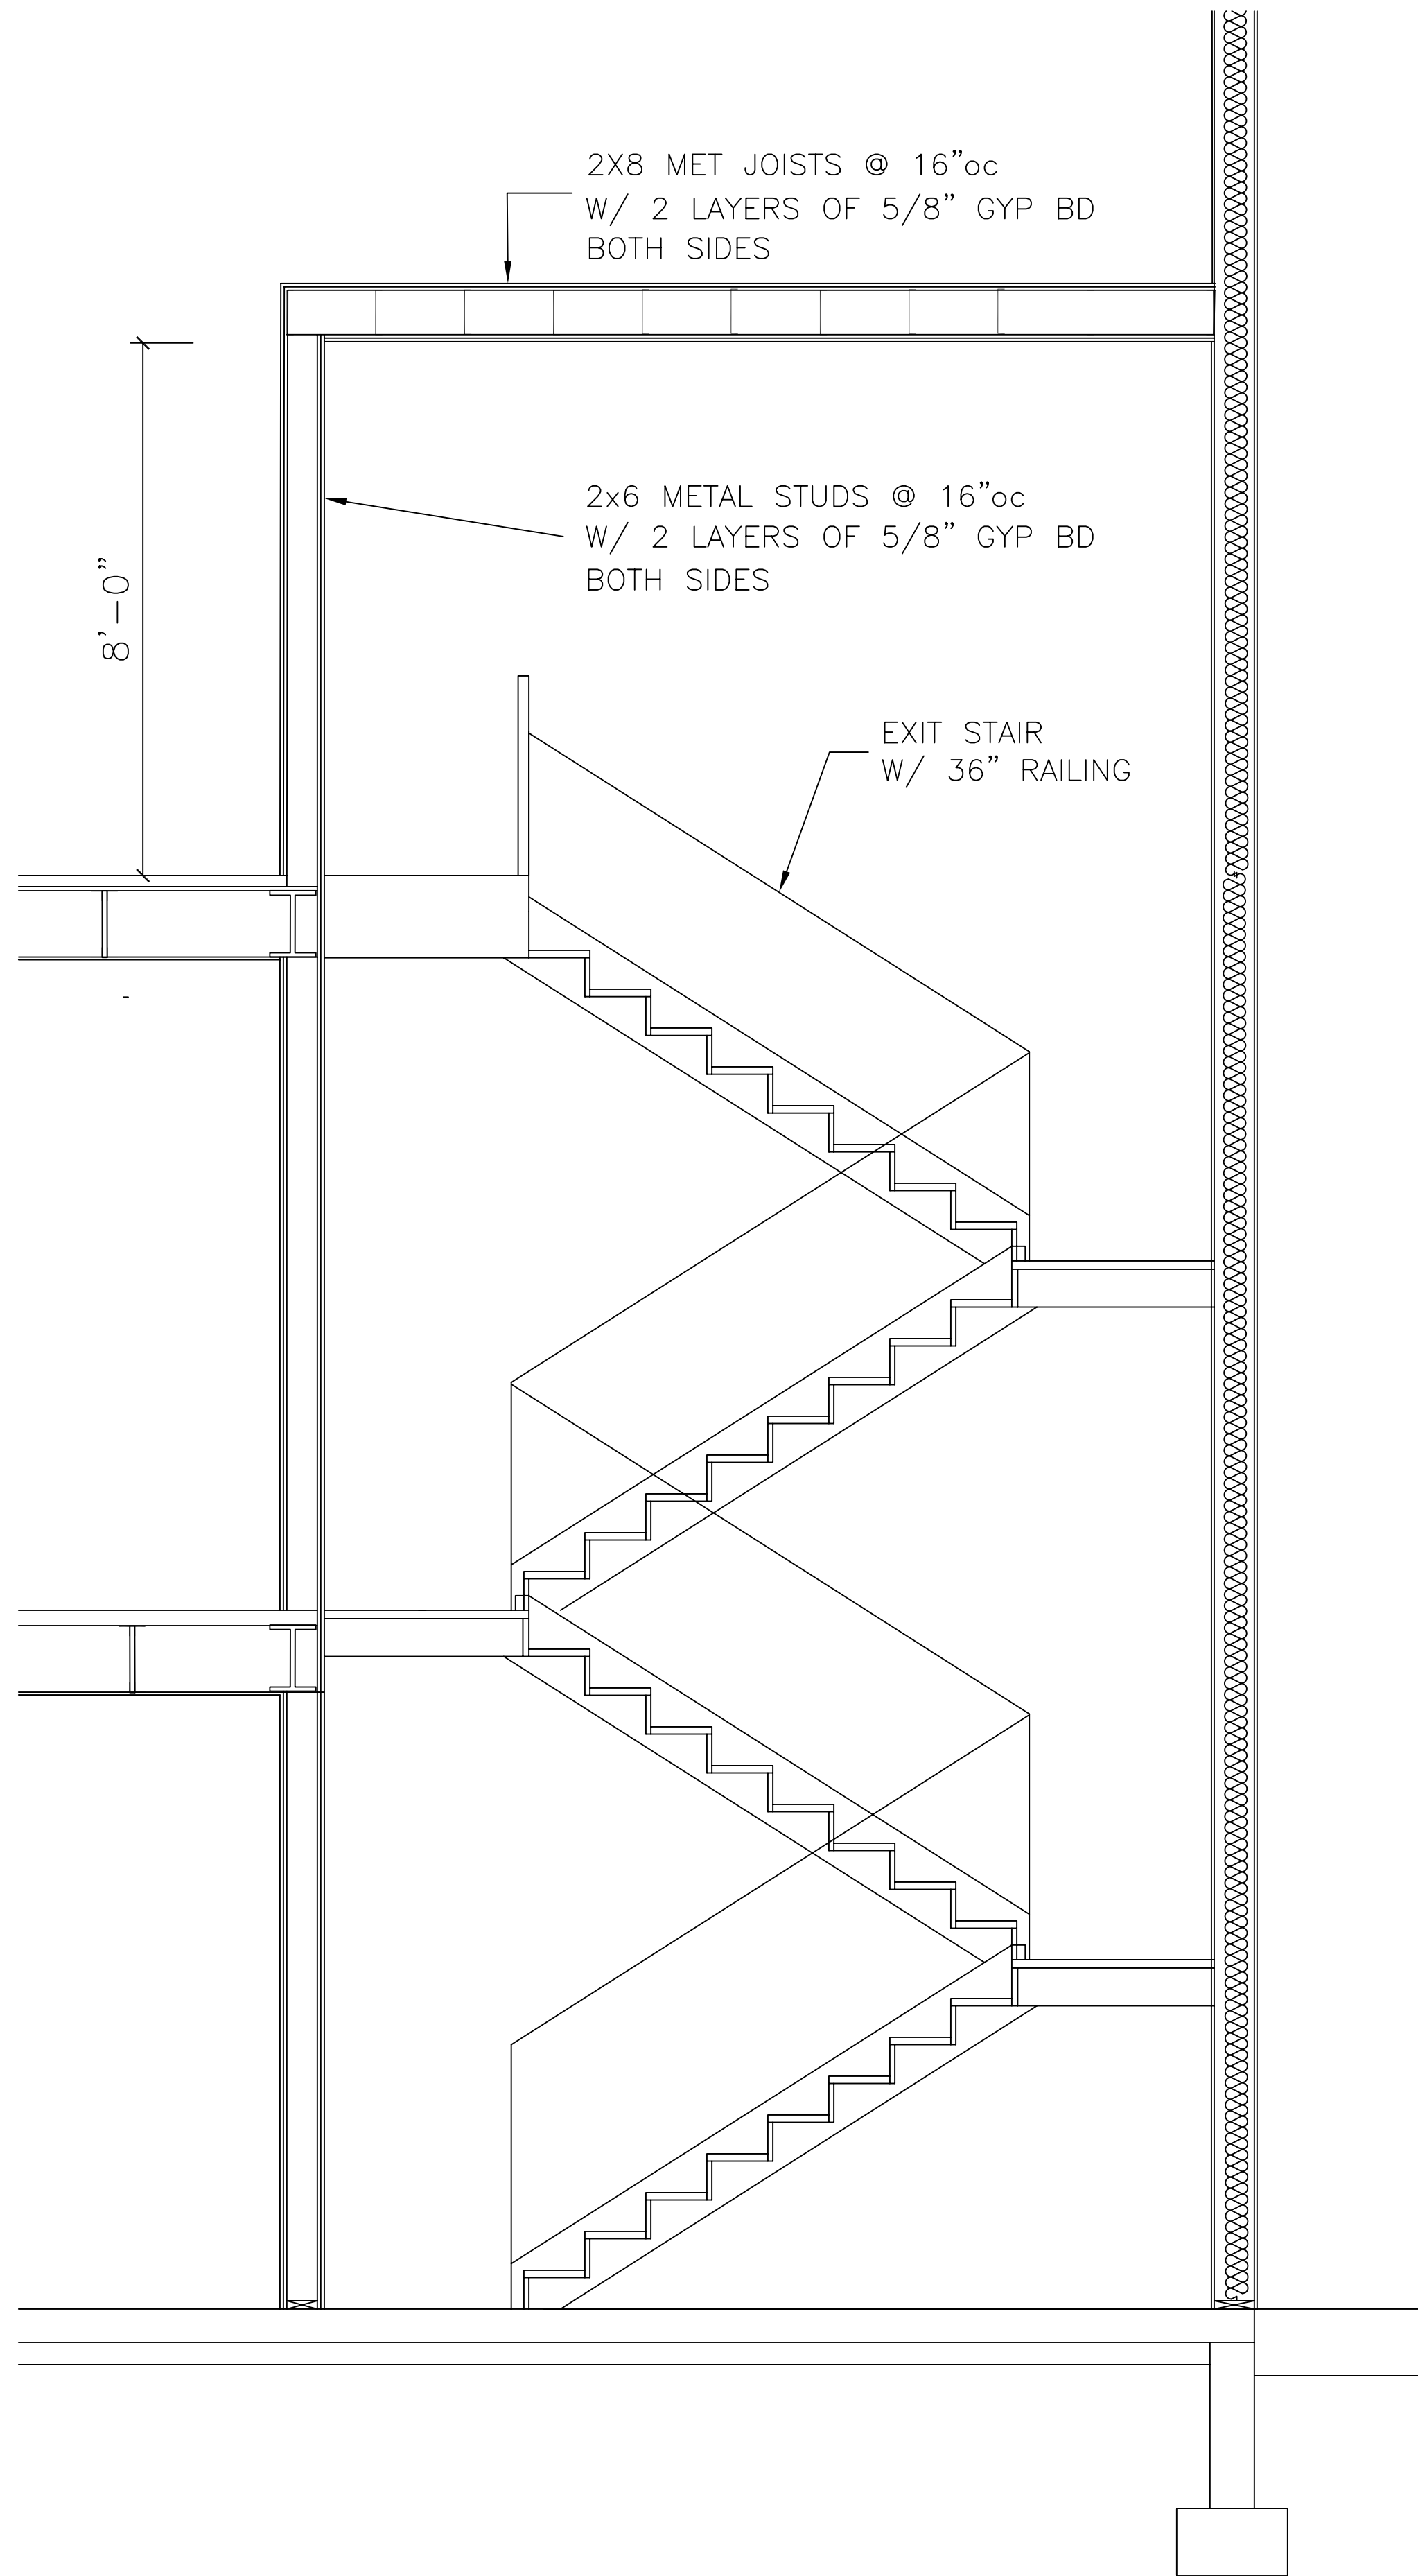


SECTION @ INTERIOR EXIT STAIR
SCALE: 3/8"=1'-0"

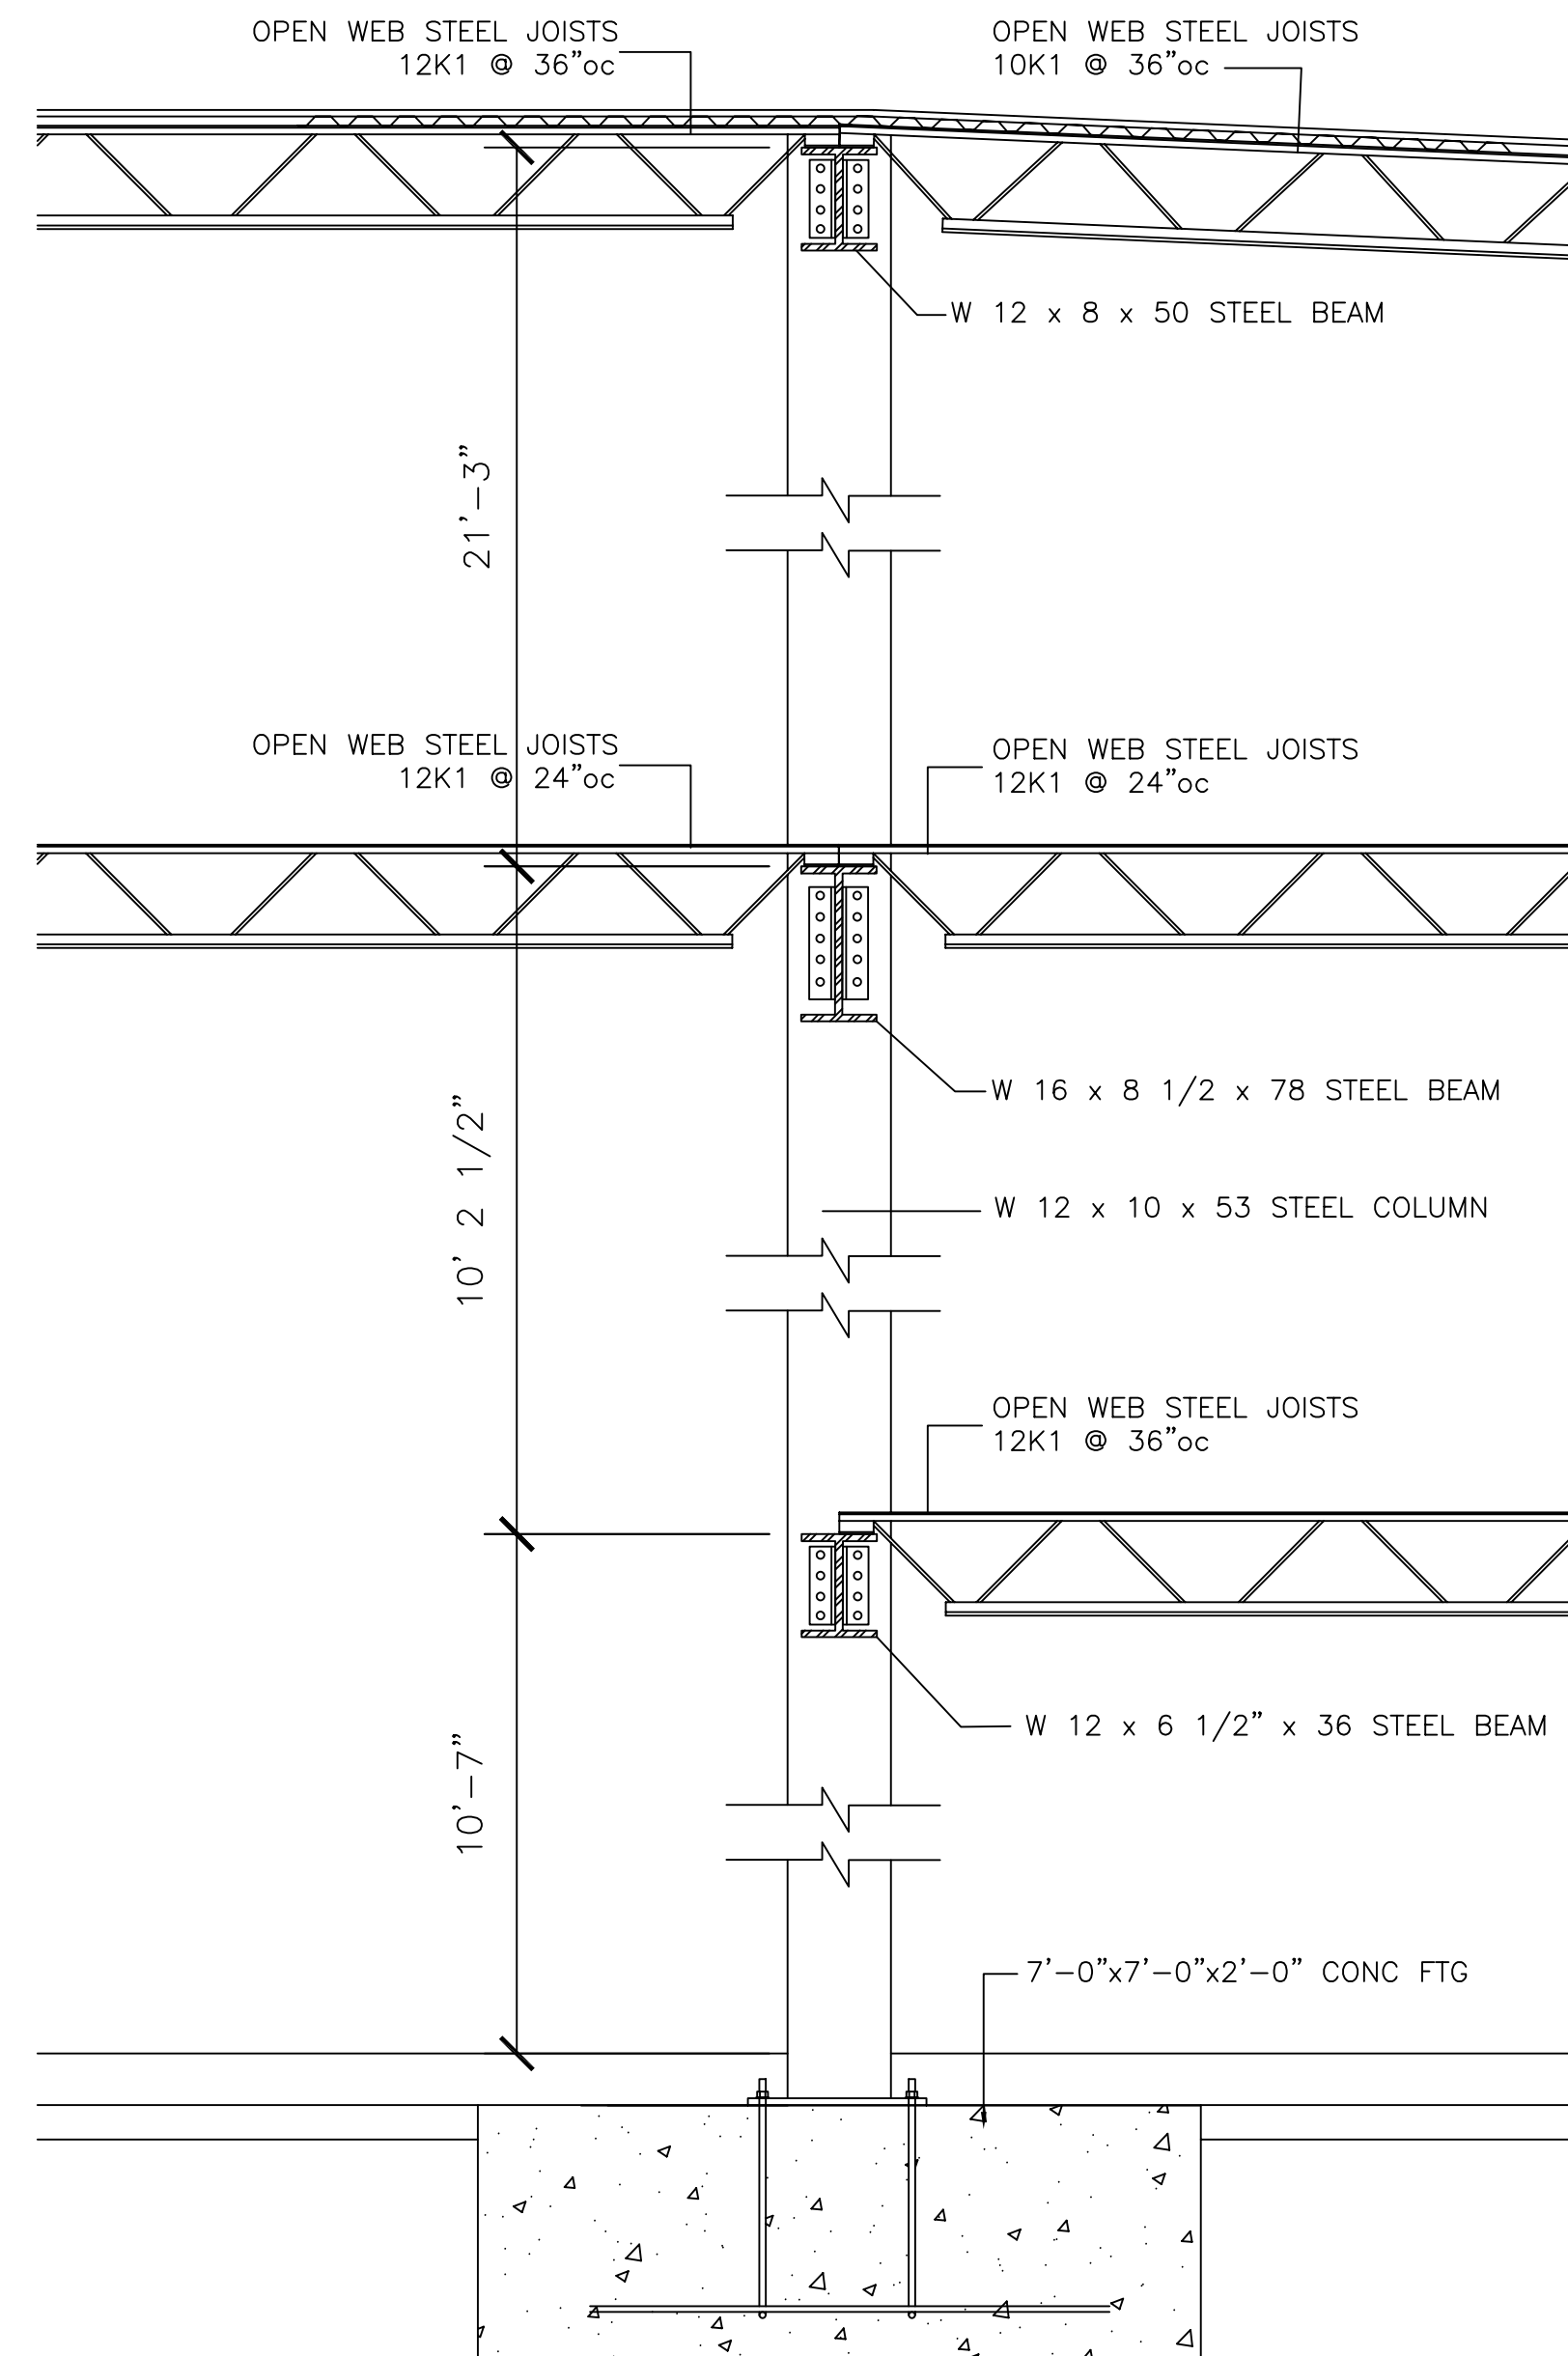


DETAIL @ INTERIOR COLUMN
SCALE: 3/4"=1'-0"

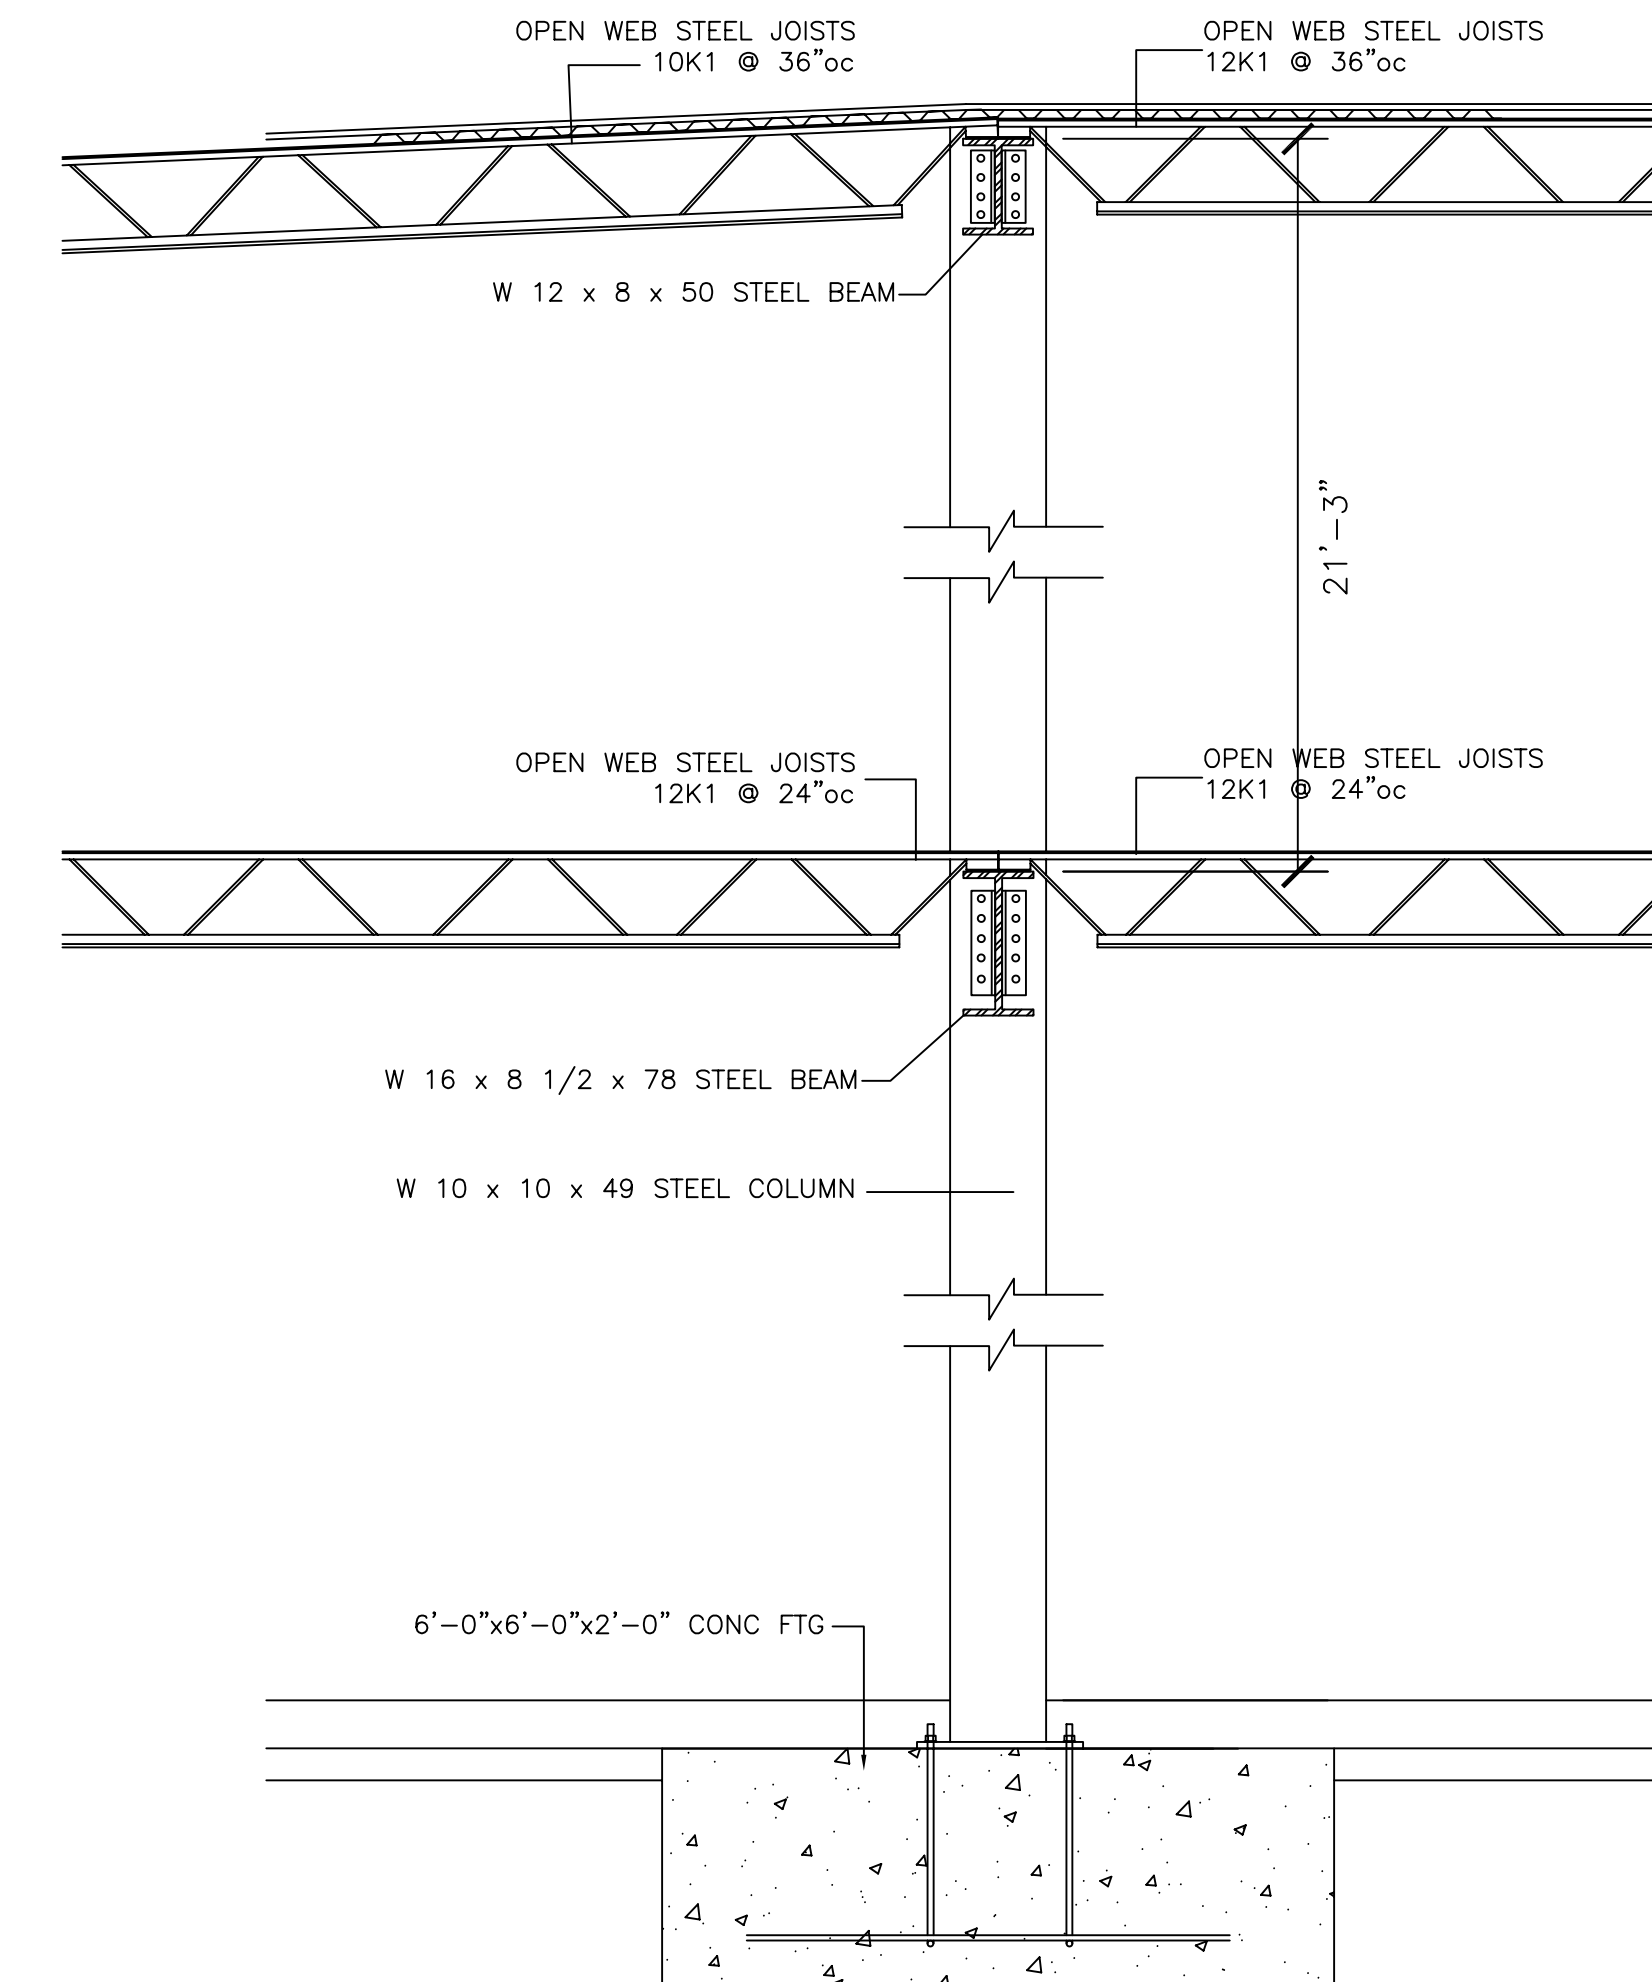

DETAIL @ INTERIOR COLUMN
SCALE: 3/4"=1'-0"

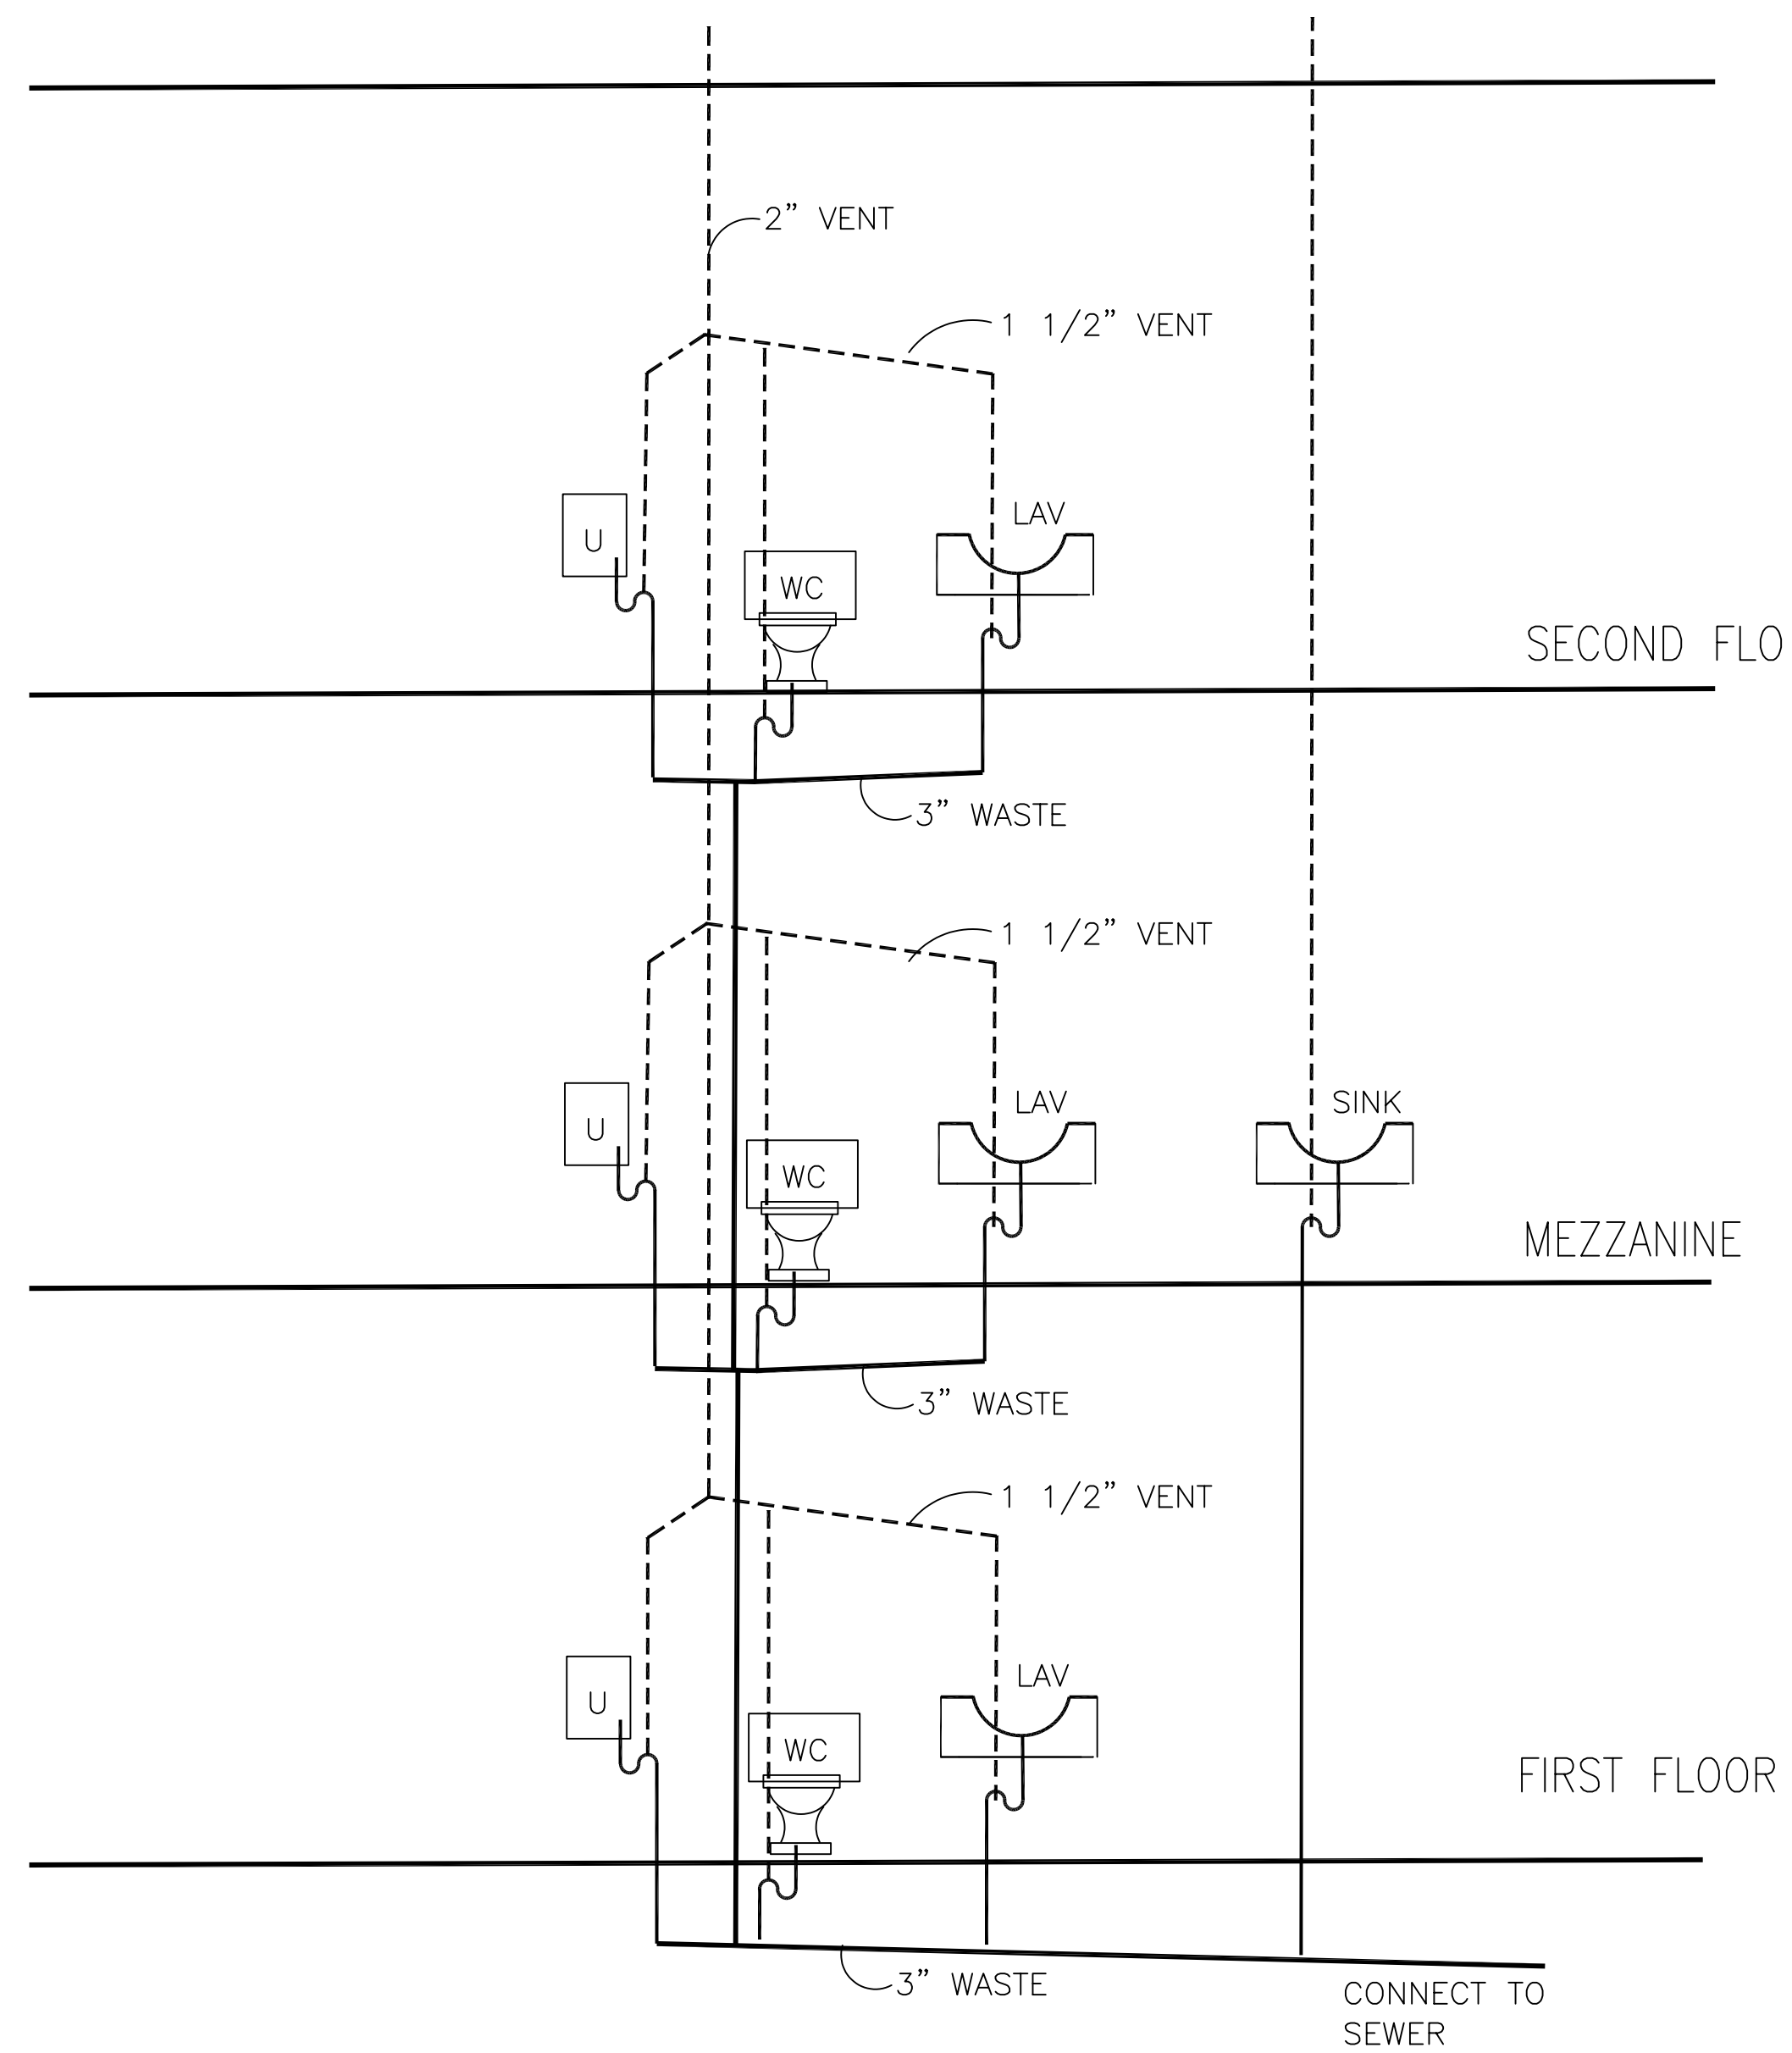


PLUMBING RISER DIAGRAM

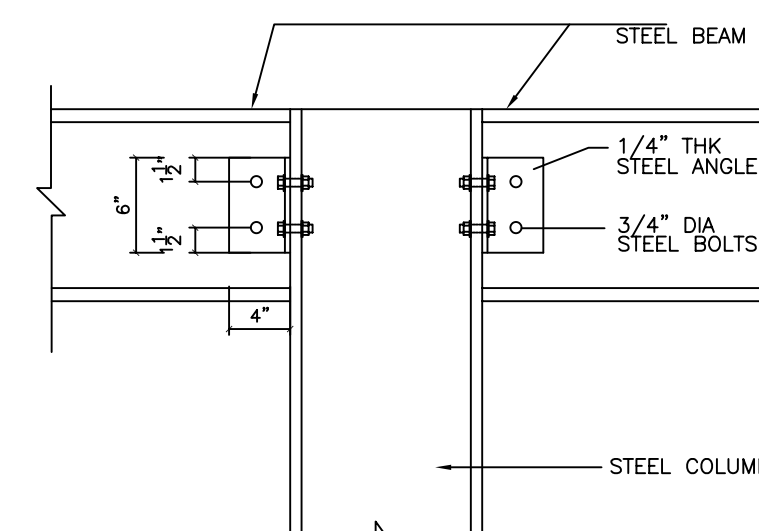


6K CONNECTION

ROOF

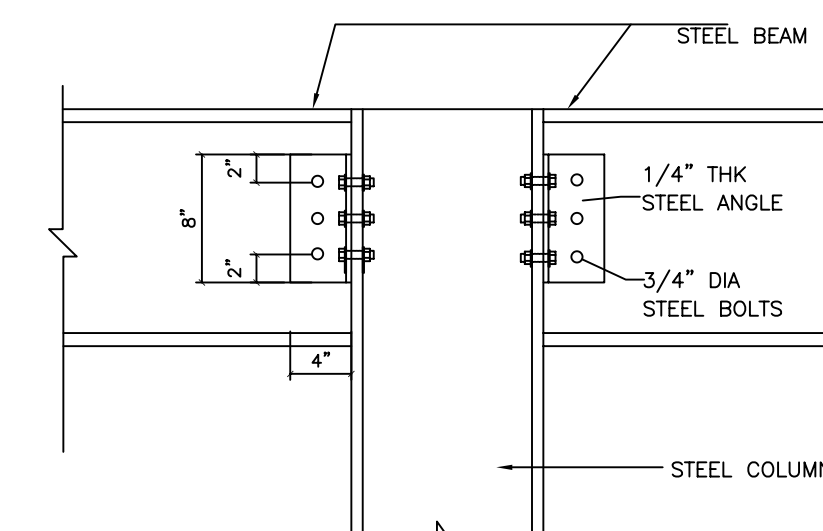


12K CONNECTION

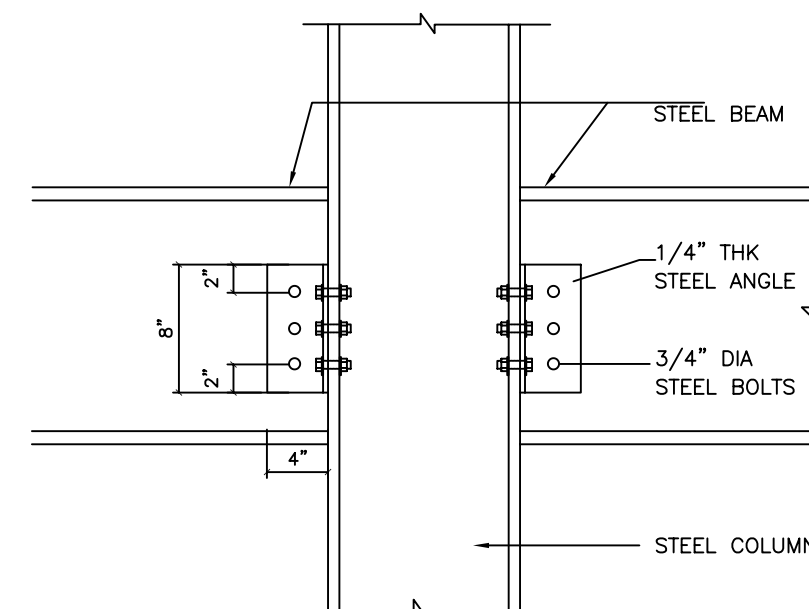


17K CONNECTION


SECOND FLOOR

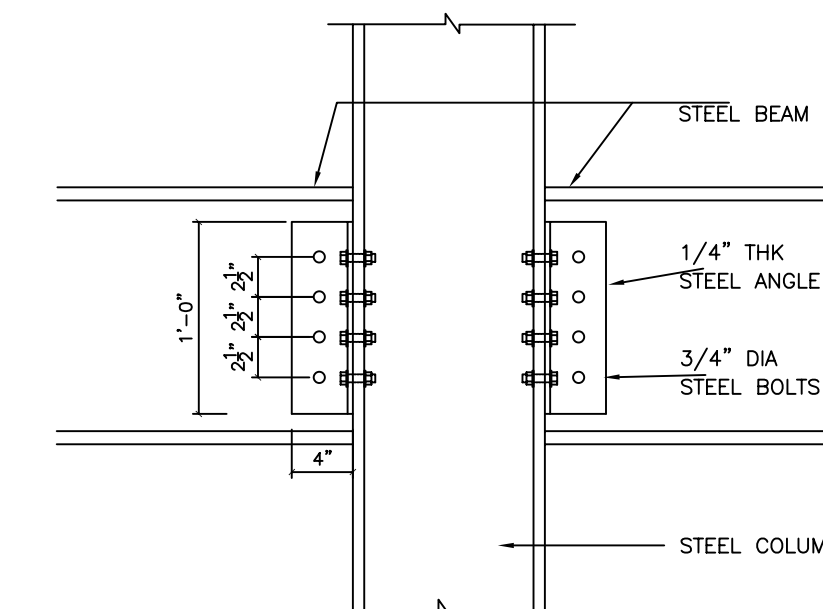

33K CONNECTION

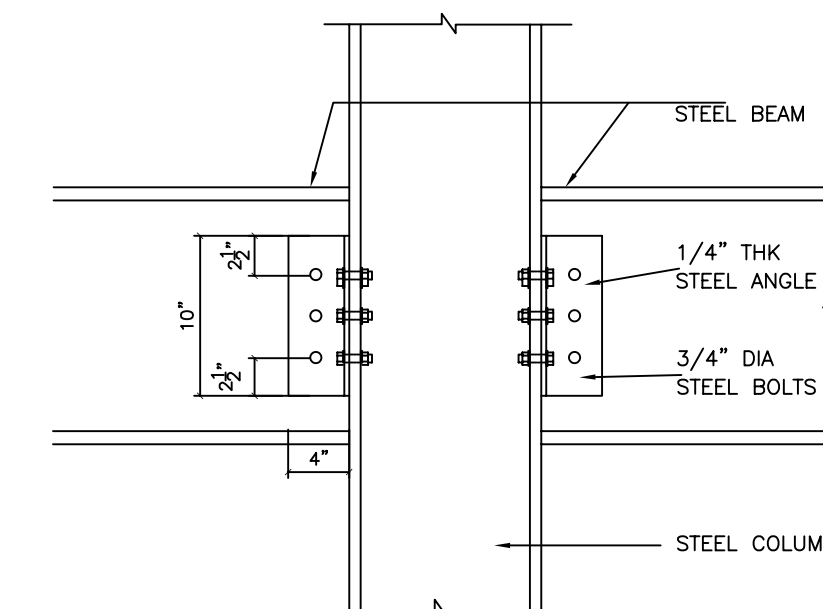

22K CONNECTION

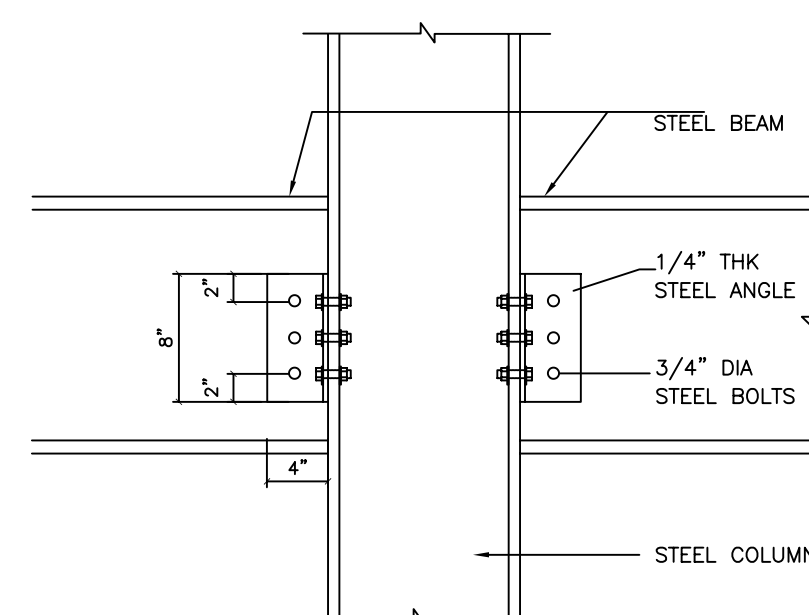


15K CONNECTION

MEZZANINE


STEEL BOLTED CONNECTIONS
SCALE: 3/16"=1'-0"

LEGEND


- | | | | | | | | |
|---|-------------------------------|---|-----------------------------|---|-------------------------------|---|-------------------|
|  | DUPLEX OUTLET |  | EXT LIGHT W/ LIGHT SENSOR |  | EXIST SIGN |  | 2X4 LIGHT FIXTURE |
|  | GFI OUTLET |  | FLUSH MOUNTED LIGHT FIXTURE |  | EMERGENCY LIGHTS |  | 2X2 LIGHT FIXTURE |
|  | SWITCH |  | EXHAUST FAN/LIGHT COMBO |  | EMERGENCY LIGHTS W/ EXIT SIGN | | |
|  | THREE-WAY SWITCH |  | HORN/STROBE | | | | |
|  | SURFACE MOUNTED LIGHT FIXTURE | | | | | | |

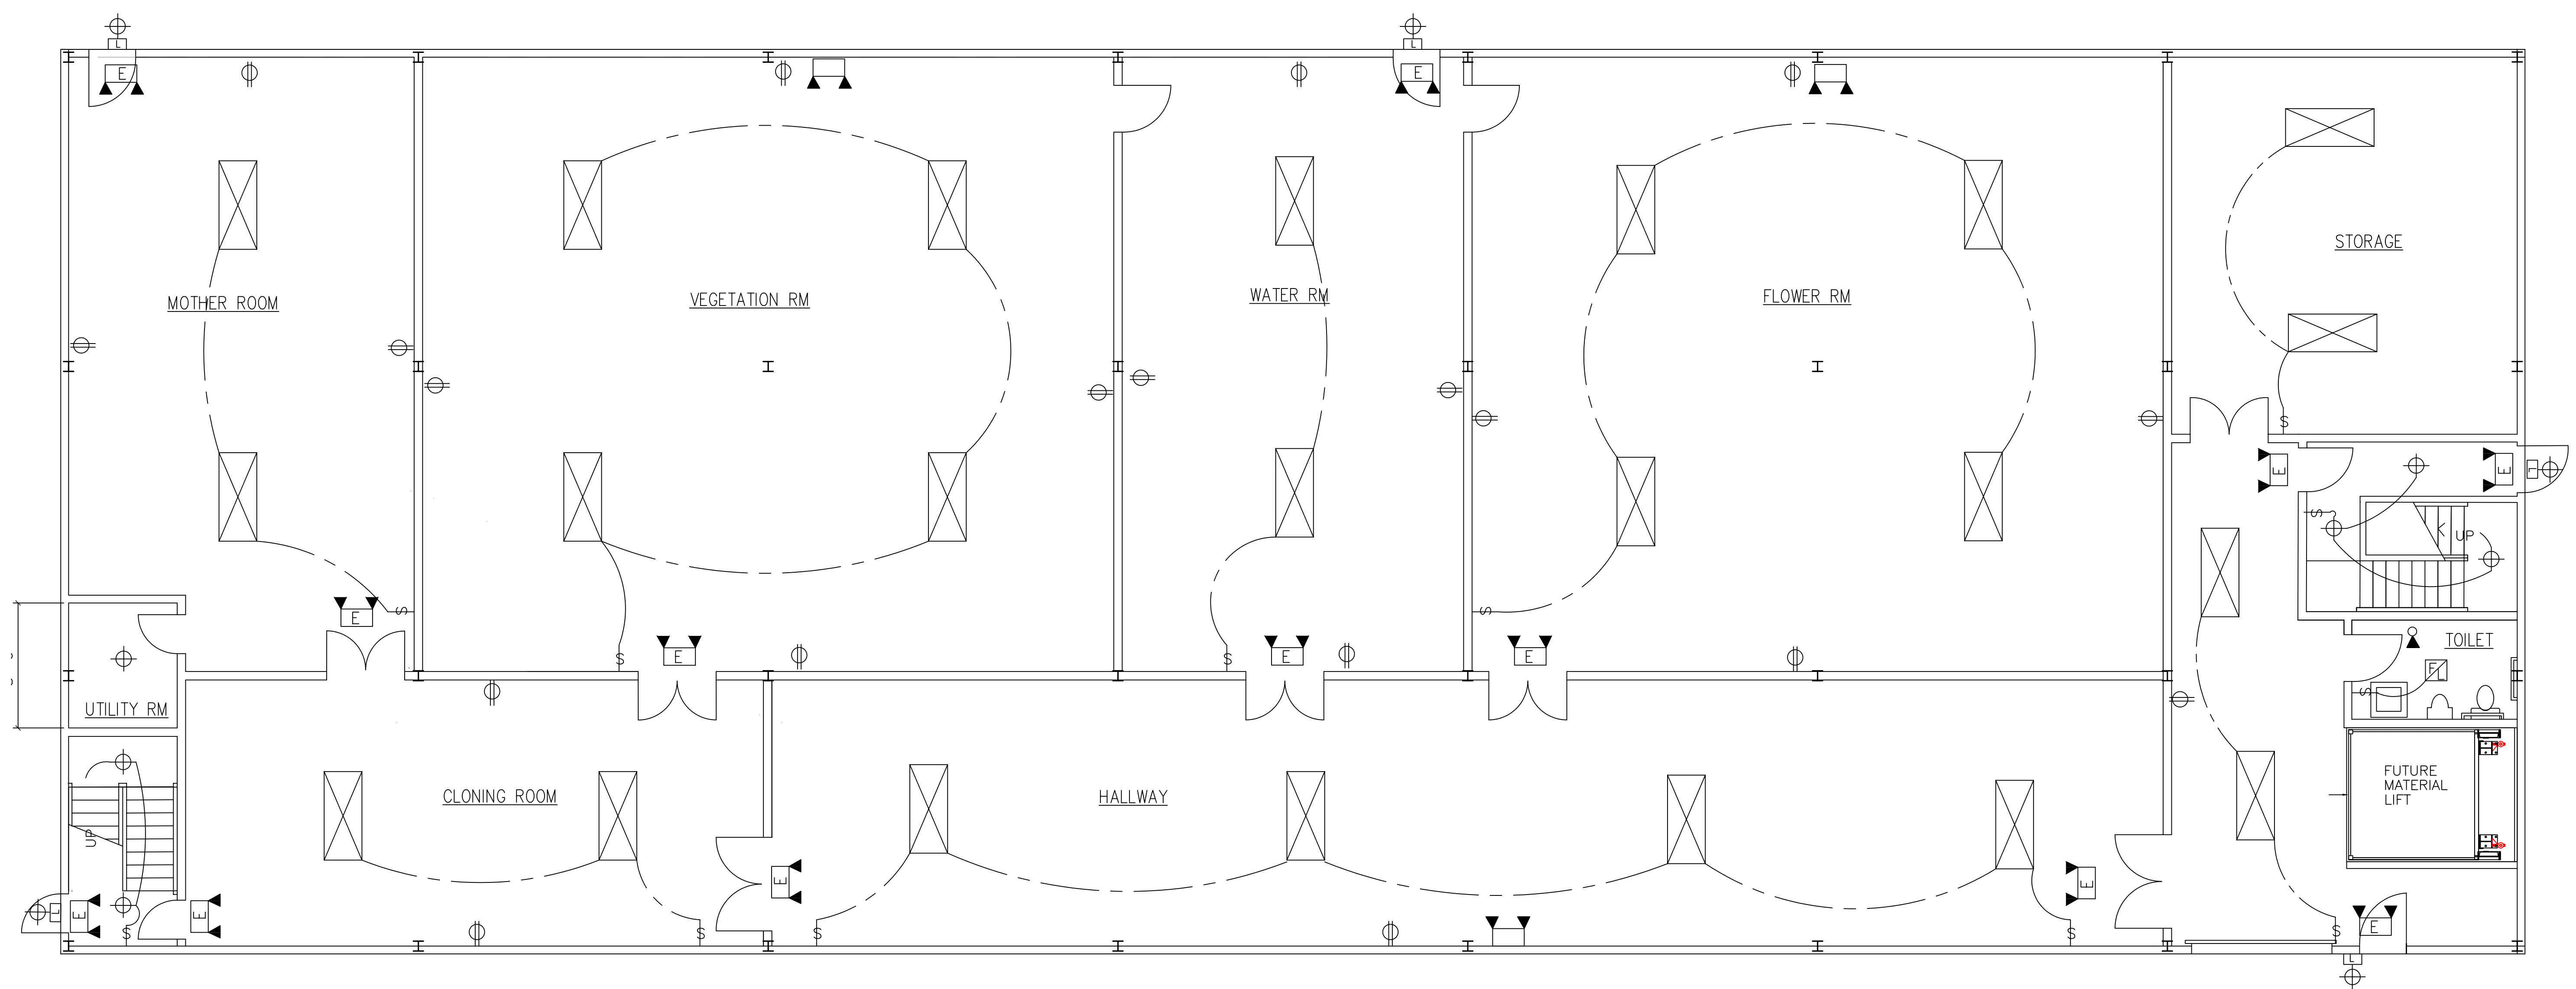

FIRST FLOOR ELECTRICAL PLAN
SCALE: 3/16"=1'-0"

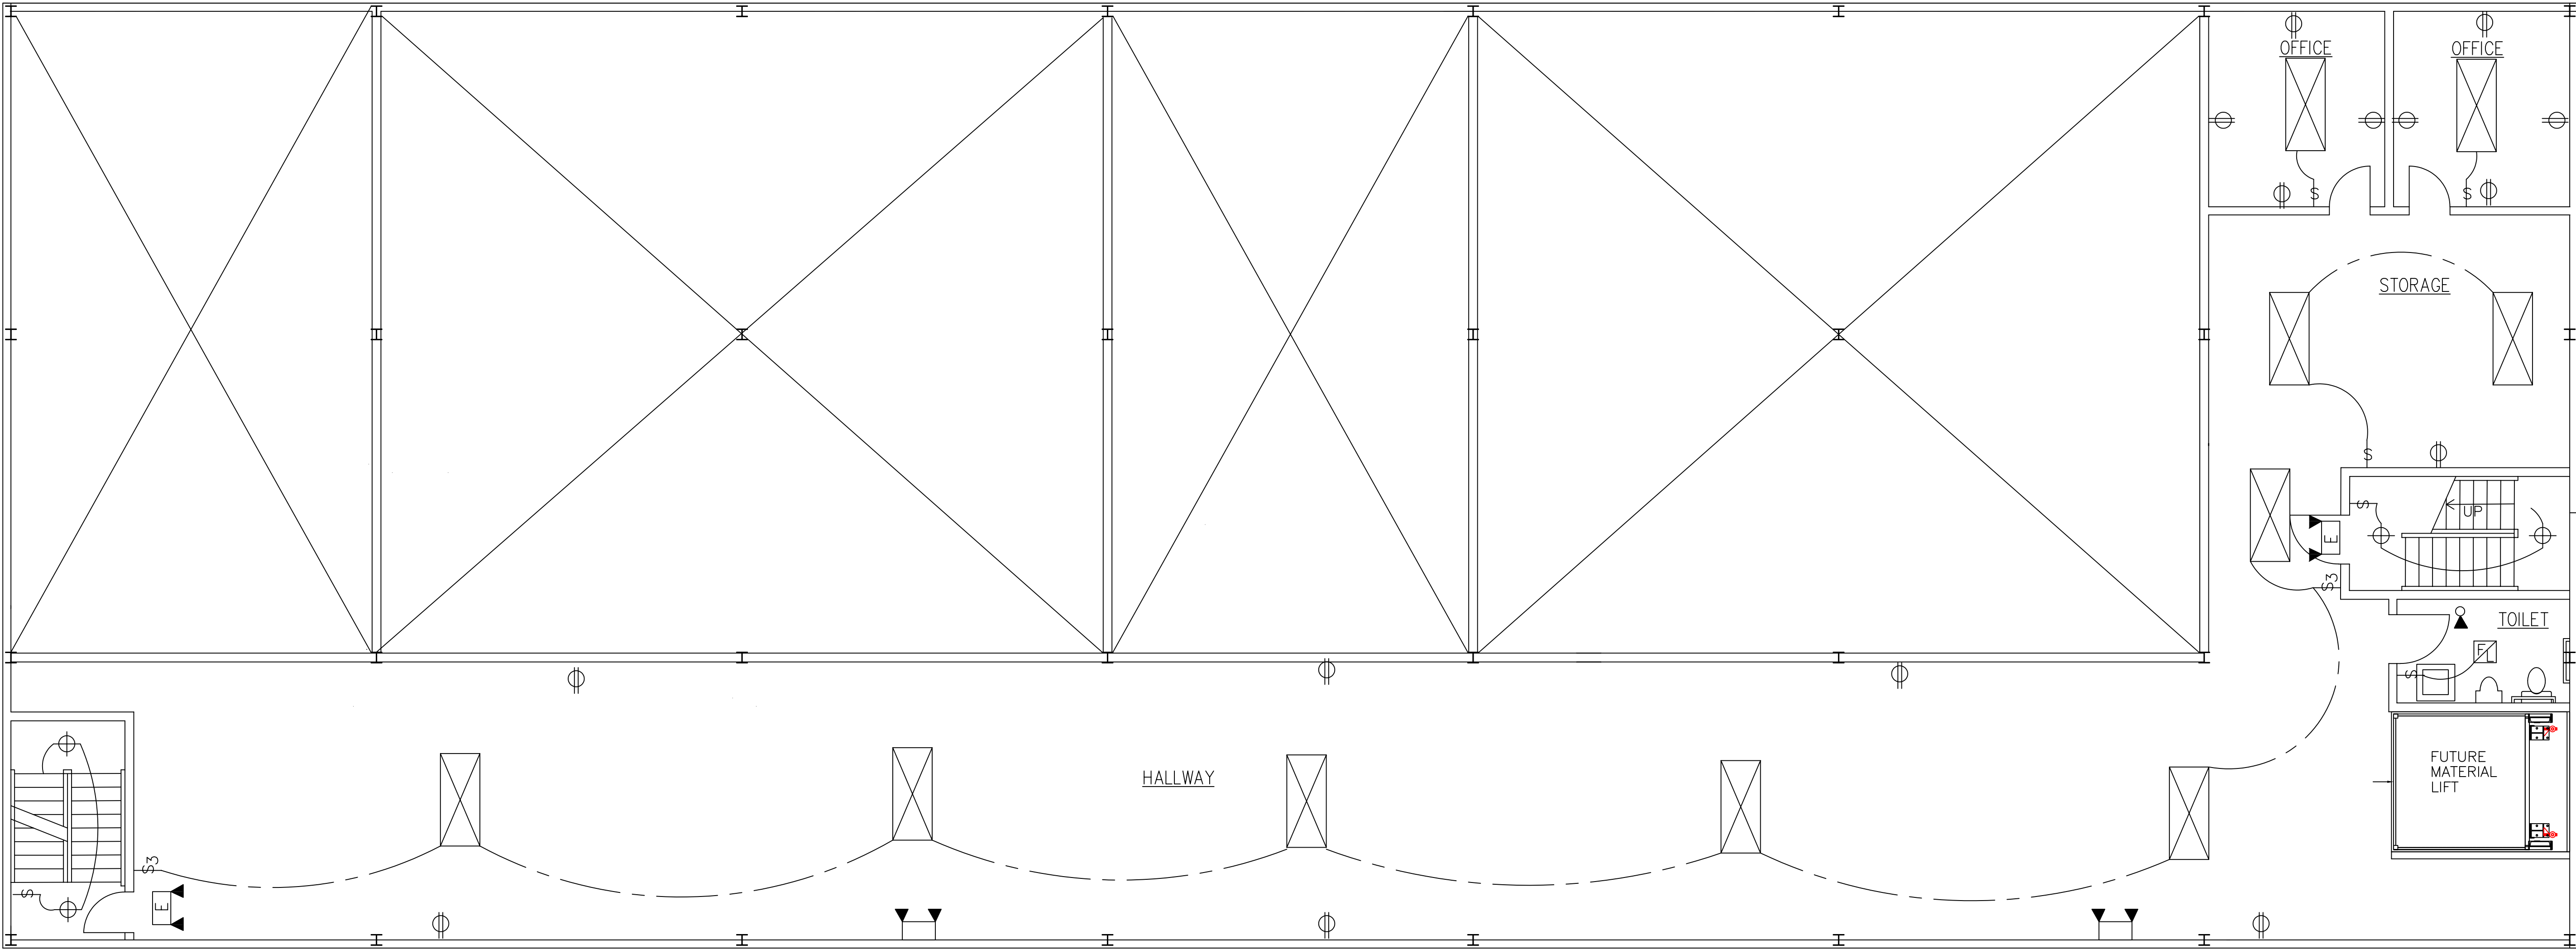

MEZZANINE ELECTRICAL PLAN
SCALE: 3/16"=1'-0"

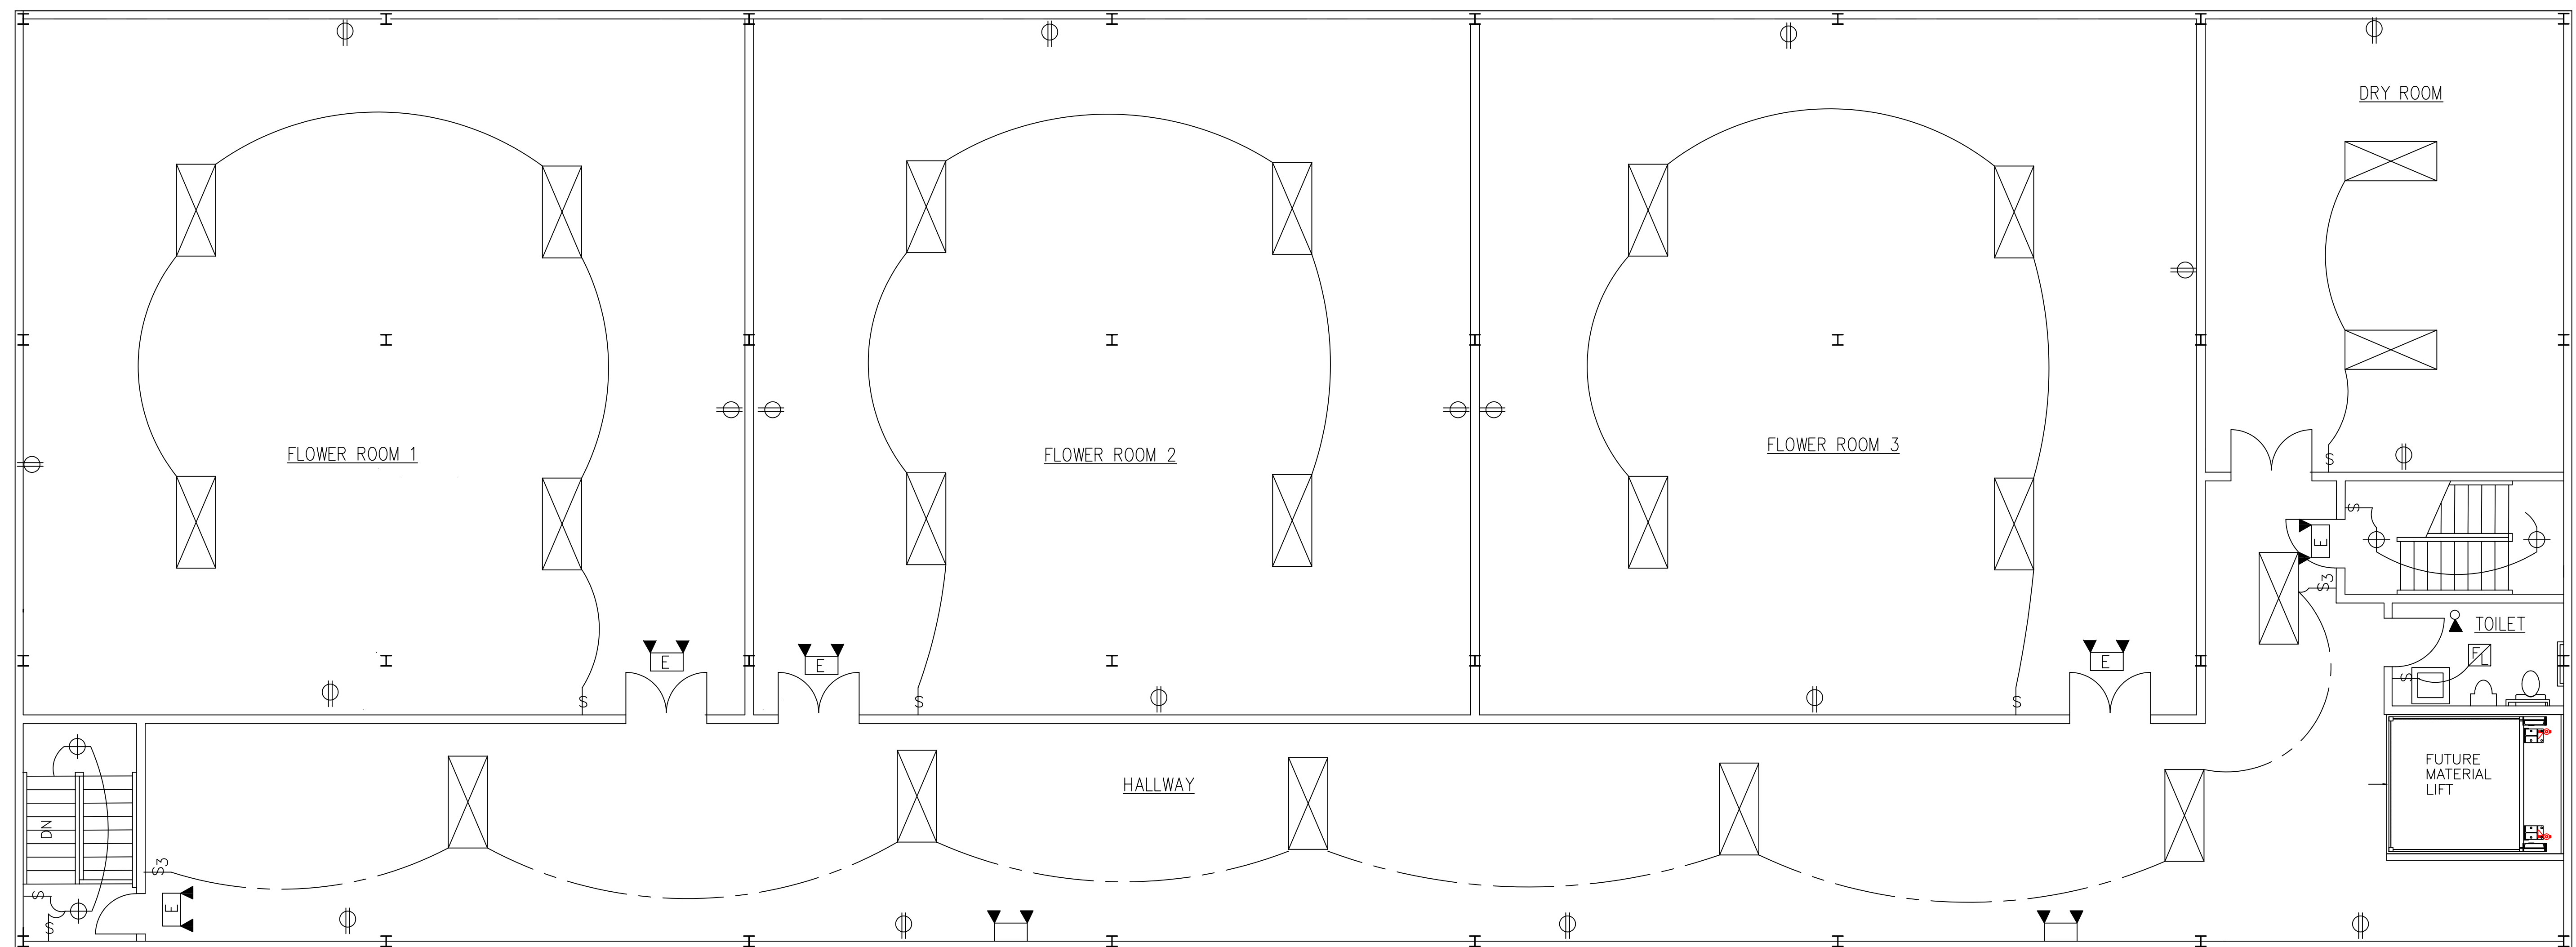

SECOND FLOOR ELECTRICAL PLAN
SCALE: 3/16"=1'-0"